



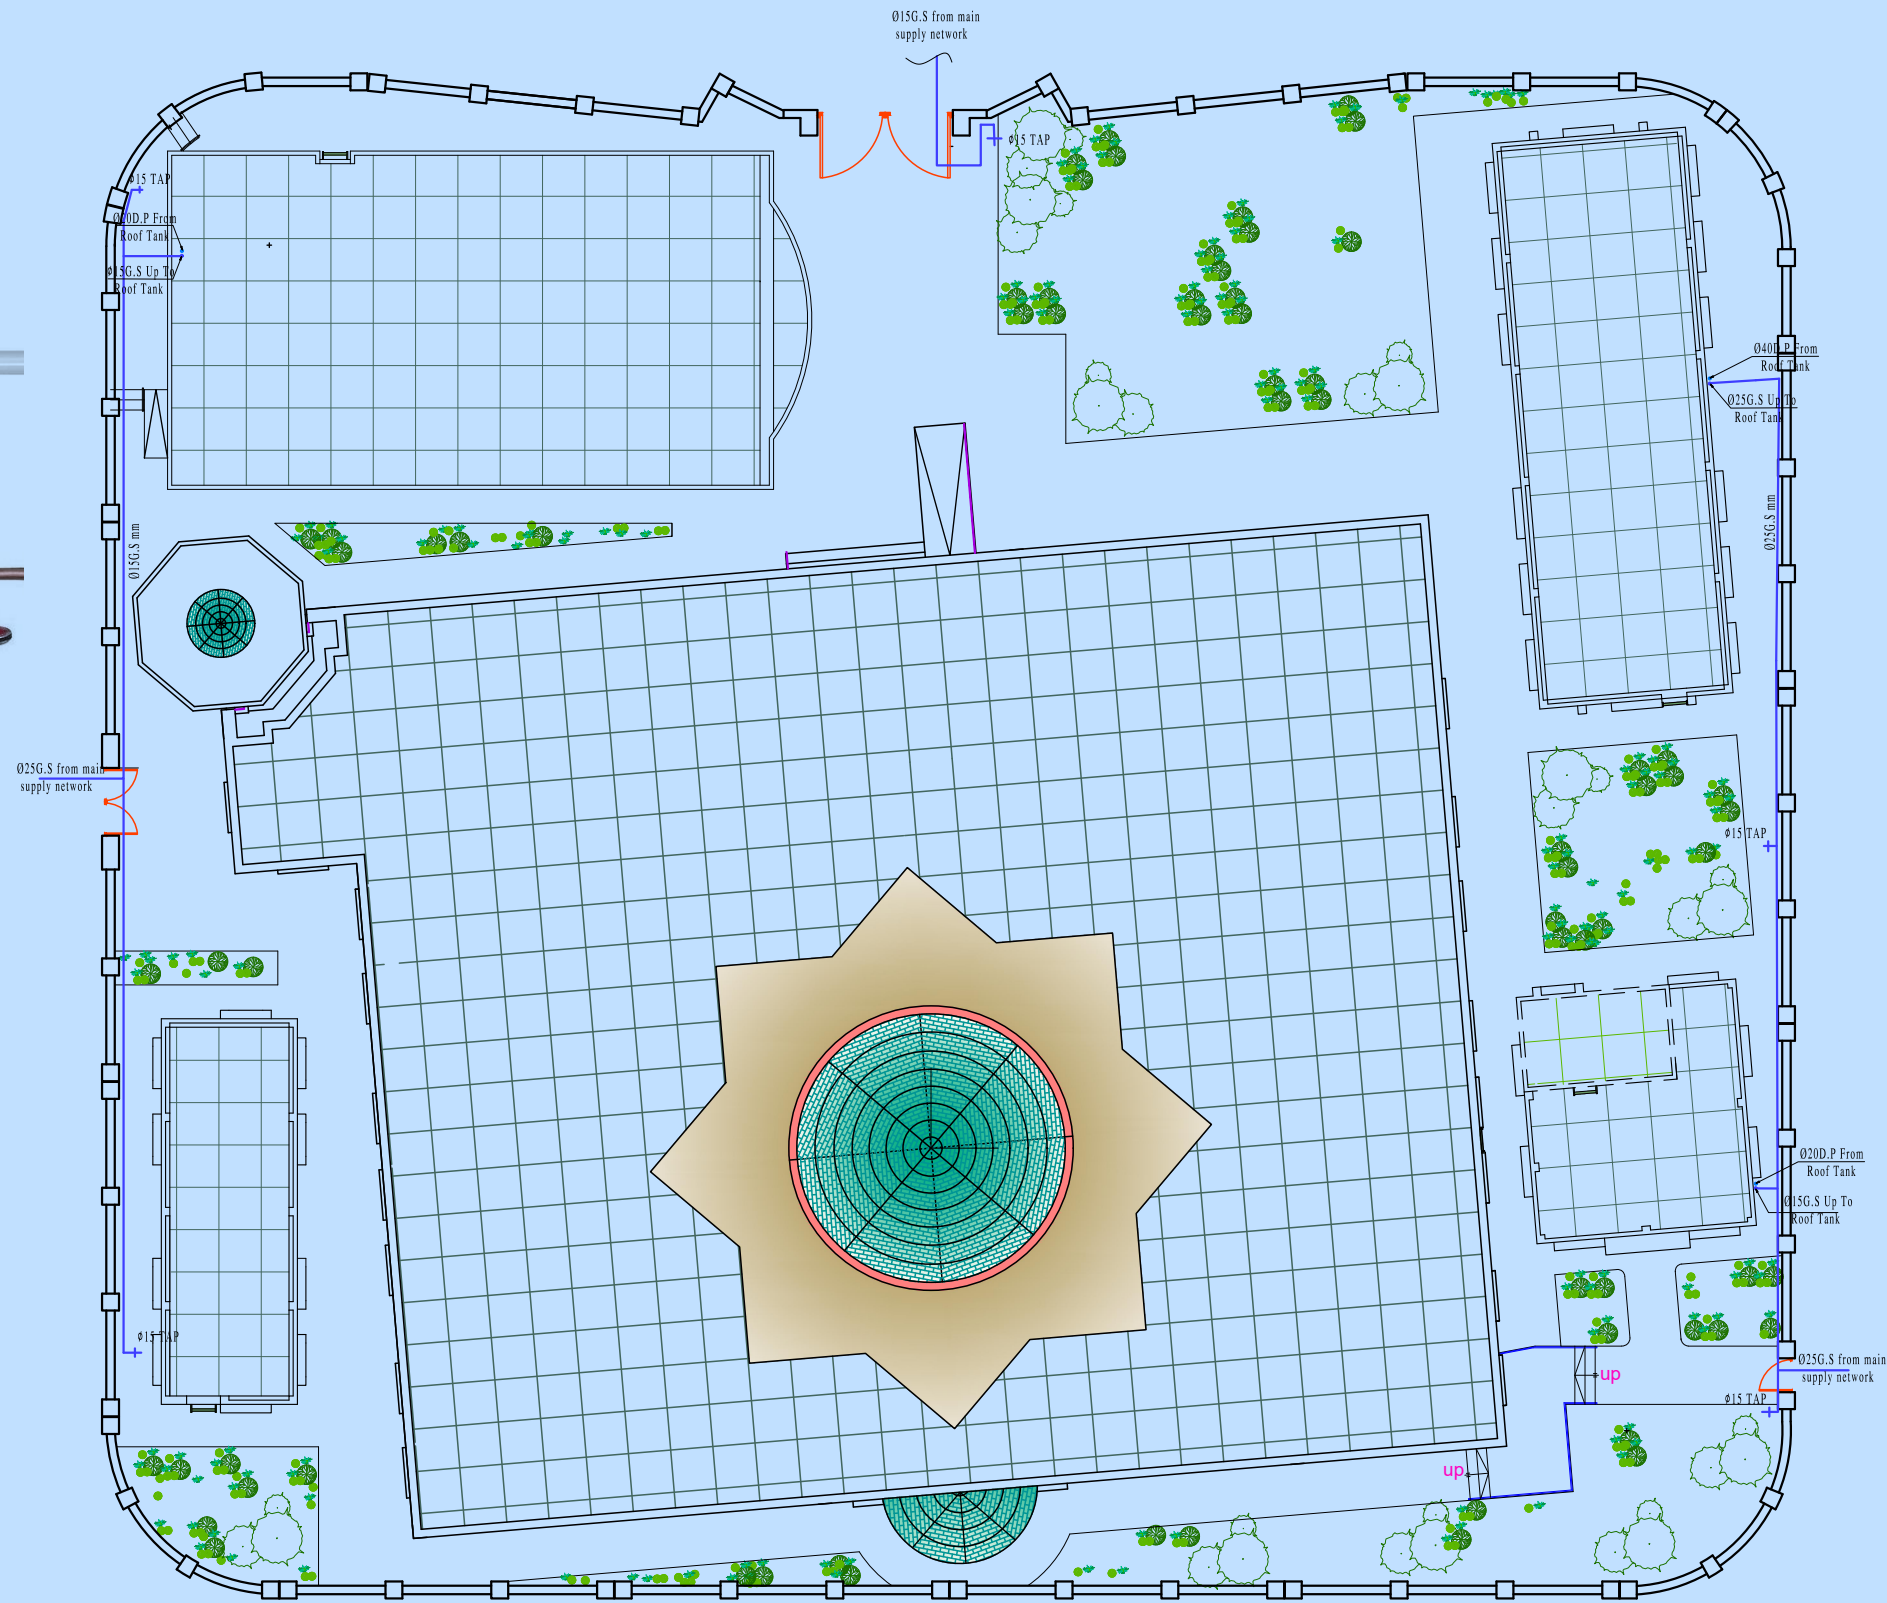

Site Plan

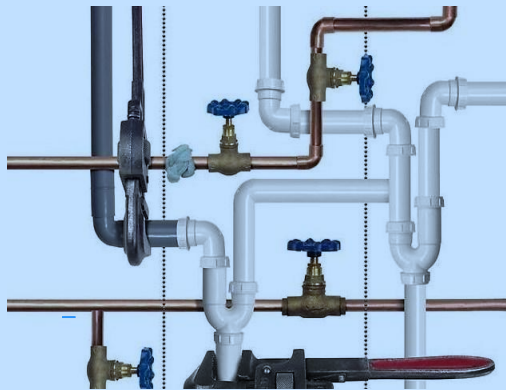

Eng MAJ D A bana
المصمم الاستشاري
د. ماجد البنا

+964 770 272 4811
+964 782 595 3403
www.majidalbana.com
majidalbana@hotmail.com

no.	date	initials	revision
job title			
(A)			
drawing title			
Drainage Plan Ground Floor			
designed DR : Majid Albana		project manager	
checked	scale 1-100	date	
drawn	job no.	sheet no.	
approved			




M

Eng MAJ D A bana

المصمم الاستشاري
د. ماجد البنا

+964 770 272 4811
+964 782 595 3403
www.majidalbana.com
majidalbana@hotmail.com

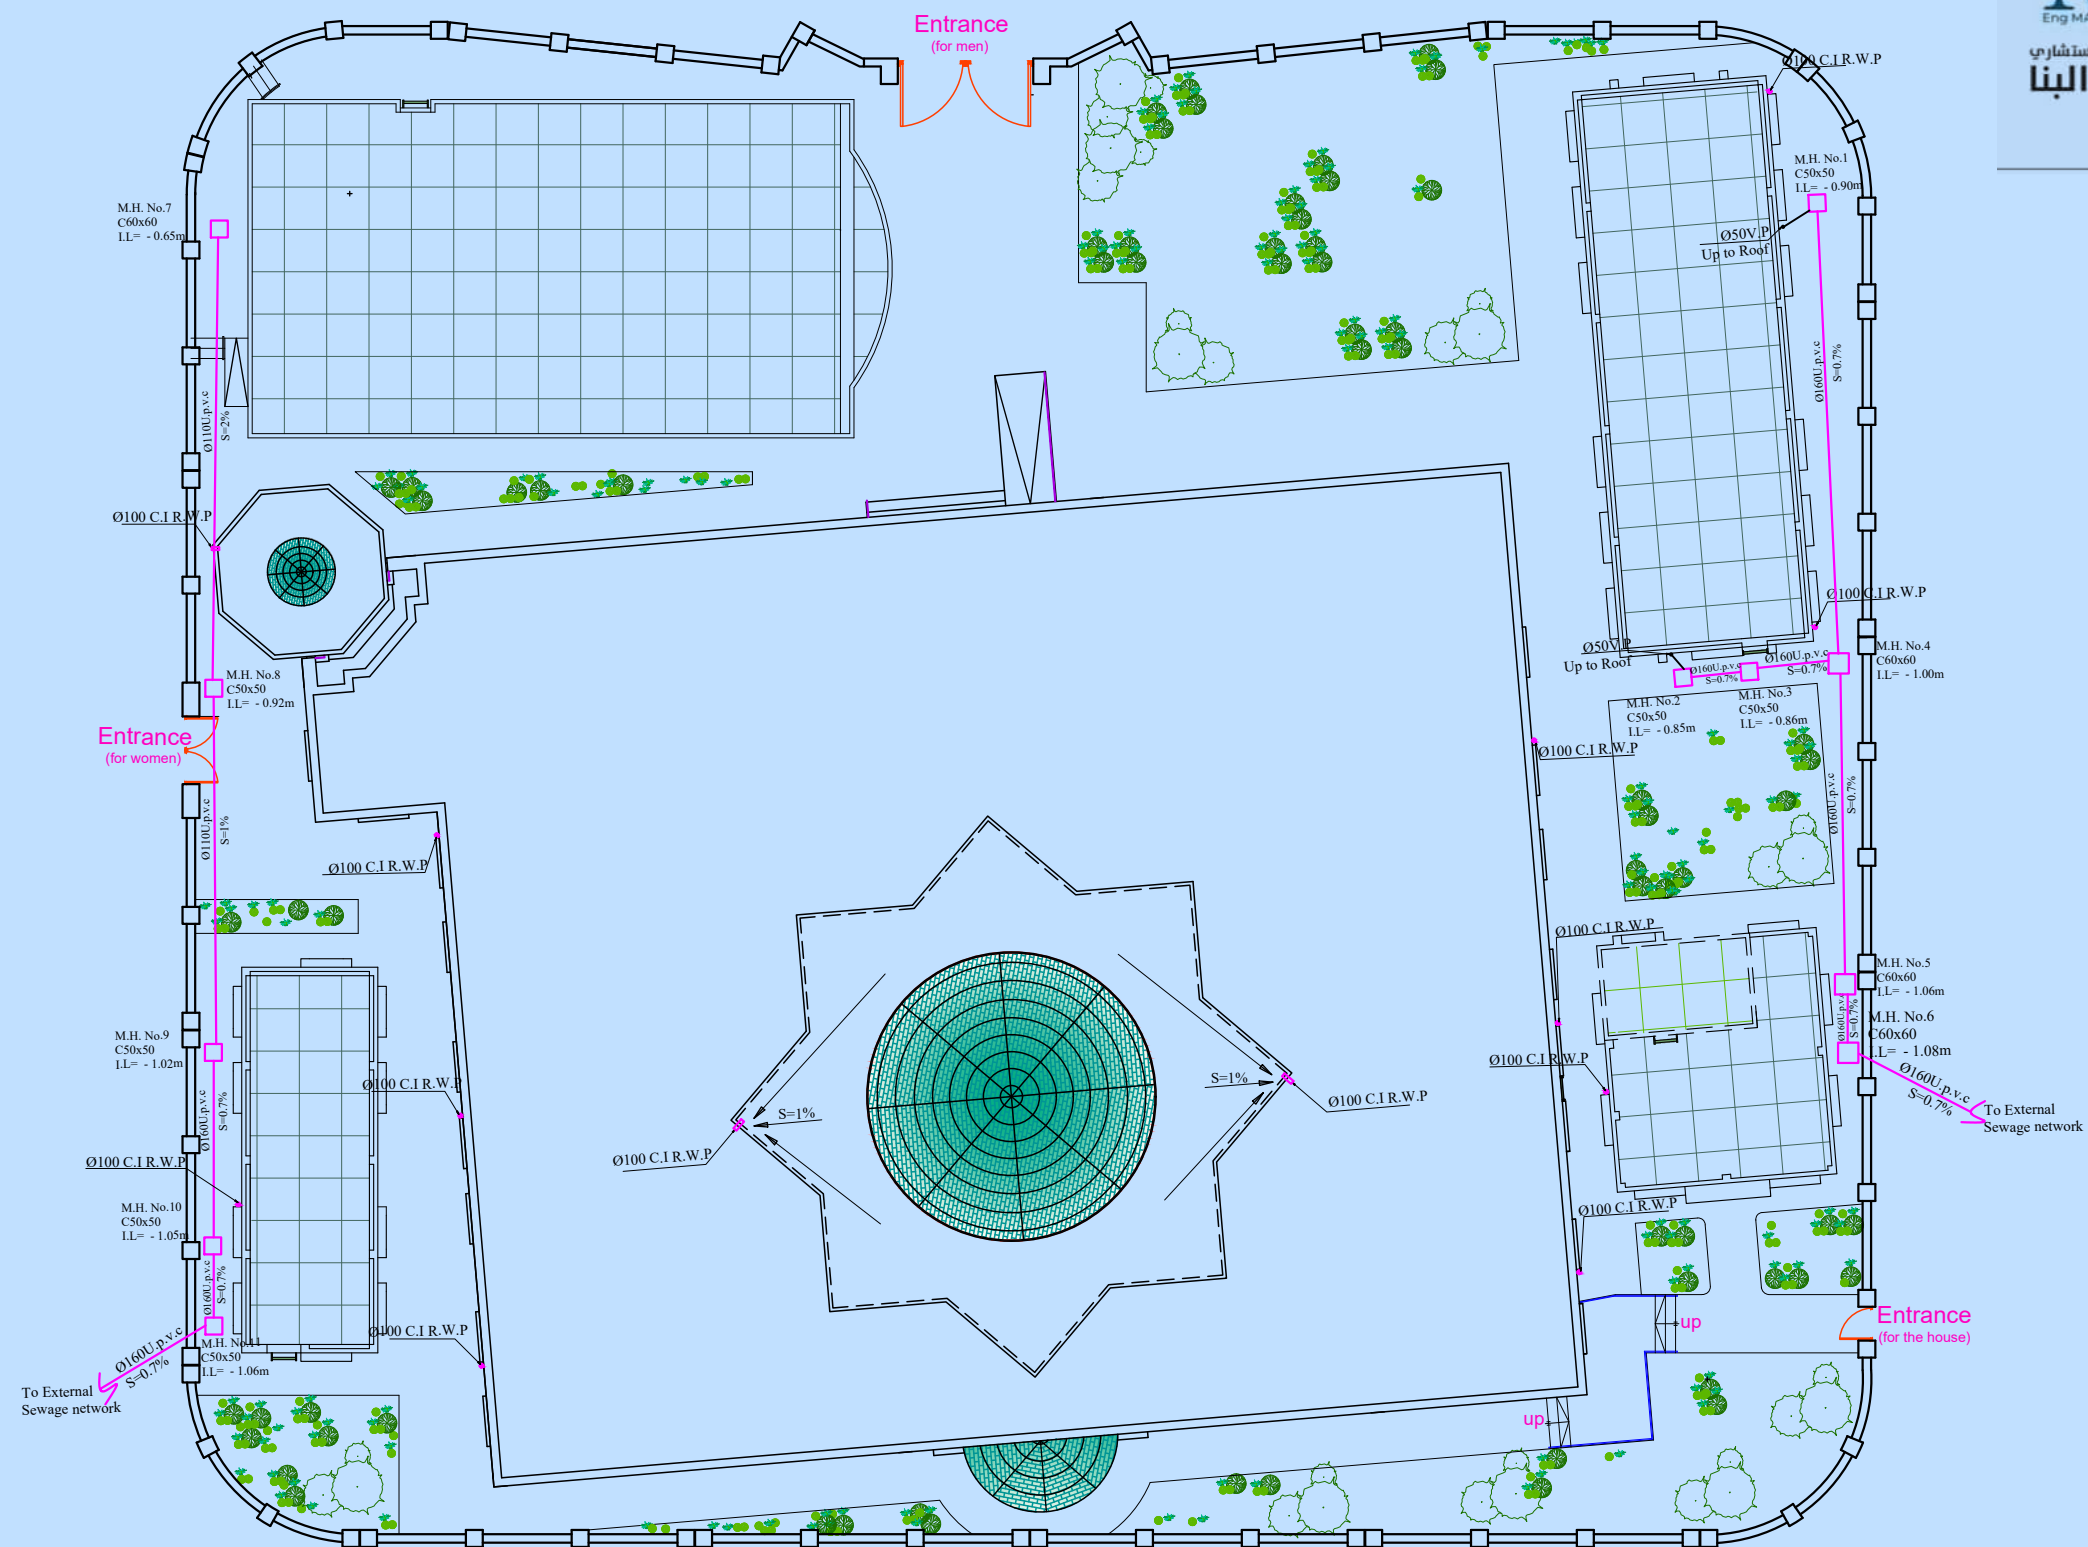

Site Plan

no	date	initials	revision
job title			
(A)			
drawing title			
Drainage Plan Ground Floor			
designed DR : Majid Albana		project manager	
checked	scale 1-100	date	
drawn	job no.	sheet no.	
approved			

M

Eng MAJ D A bana

المصمم الاستشاري


د. ماجد البنا

+964 770 272 4811



+964 782 595 3403

www.majidalbana.com

majidalbana@hotmail.com

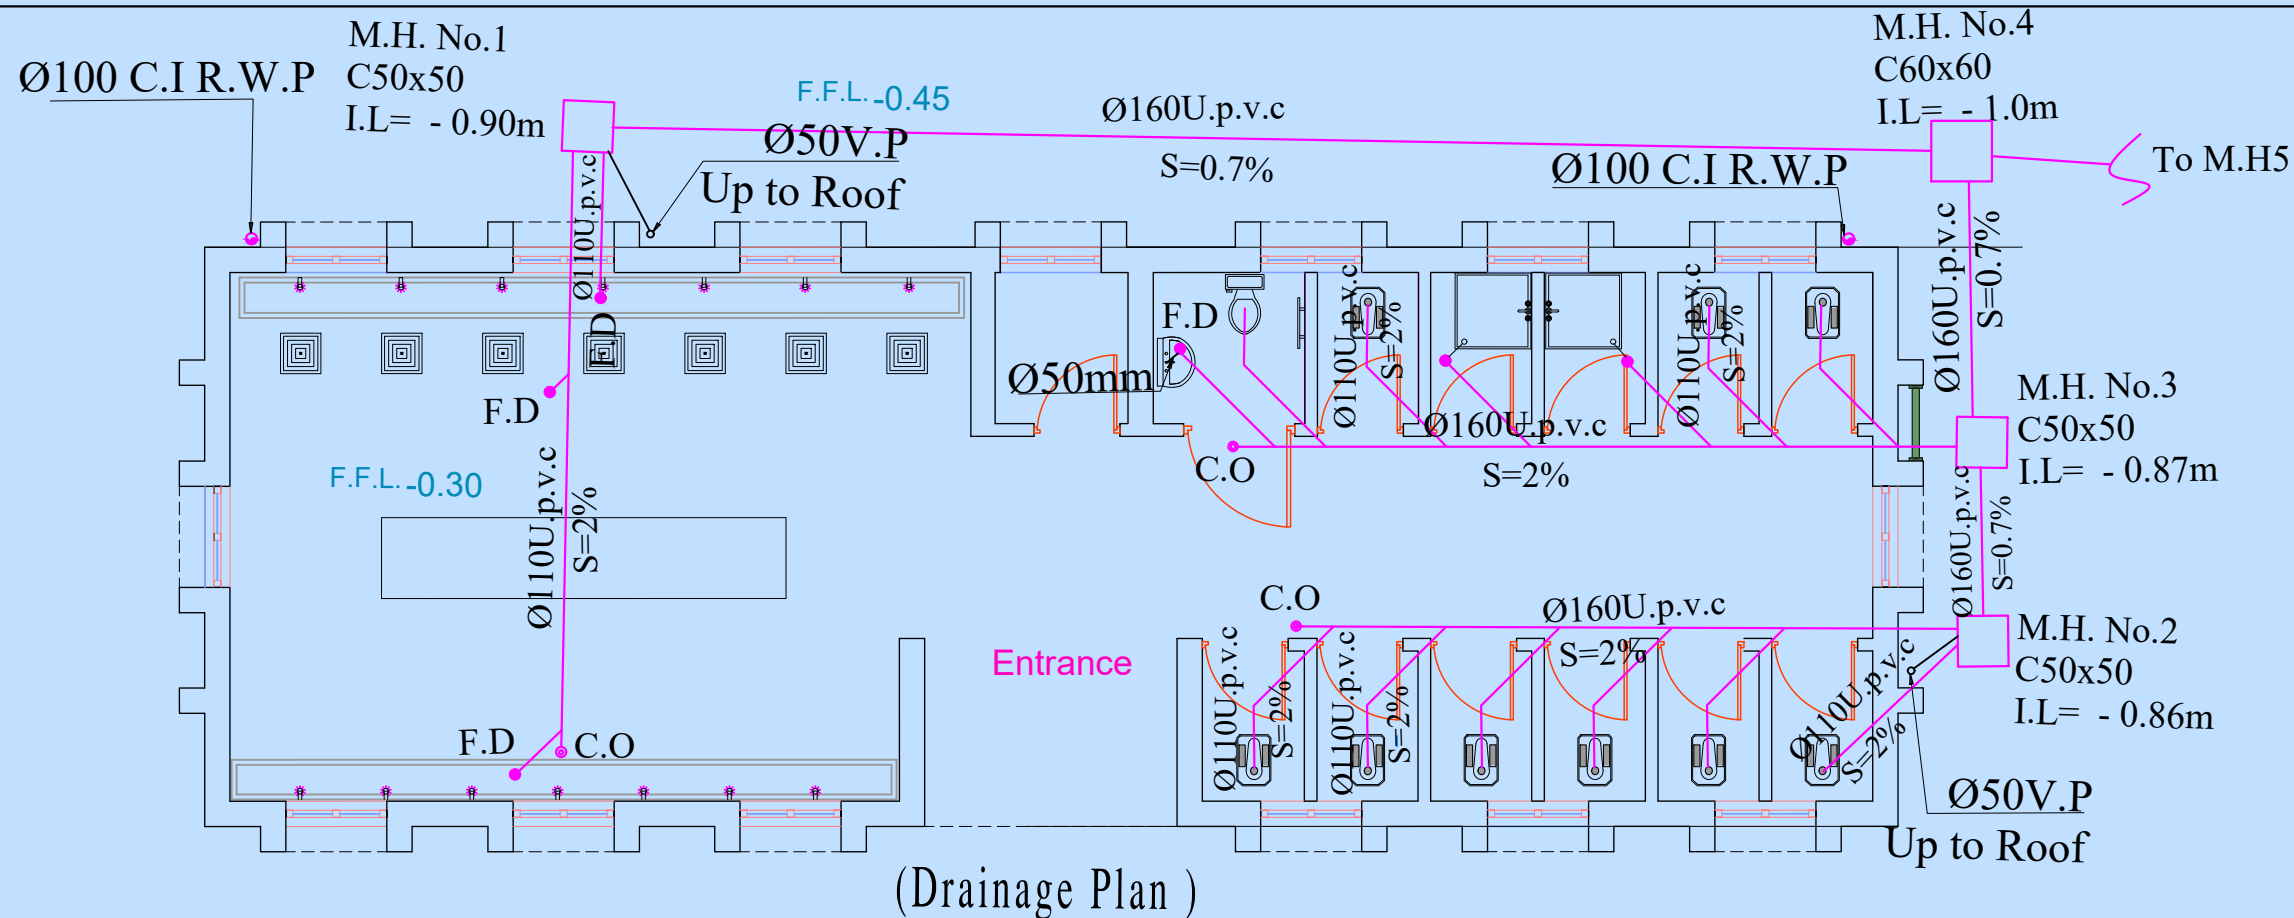

LEGEND	
SYMBOL	DESCRIPTION
	Ø110FLOOR DRAIN (F.D)
	C.O.(Ø110) CLEAN OUT
	MANHOLE FOR SEWAGE
	RAIN WATER PIPE (R.W.P)
	MAIN WATER SUPPLY PIPE(M.W.P)
	COLD WATER SUPPLY PIPE
	HOT WATER SUPPLY PIPE

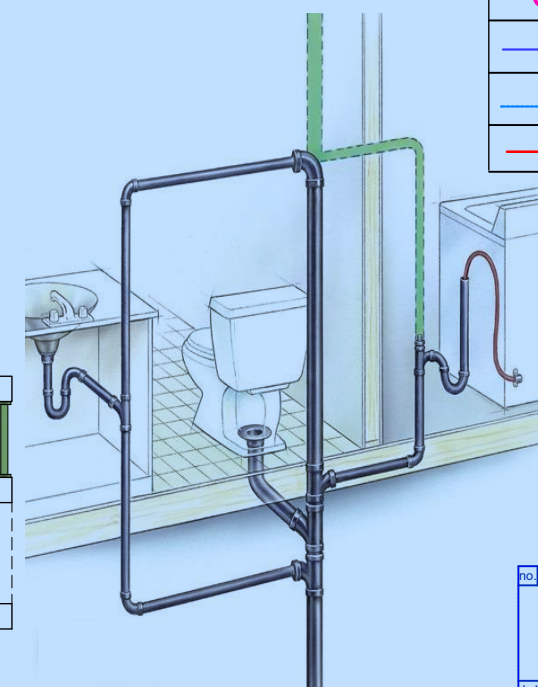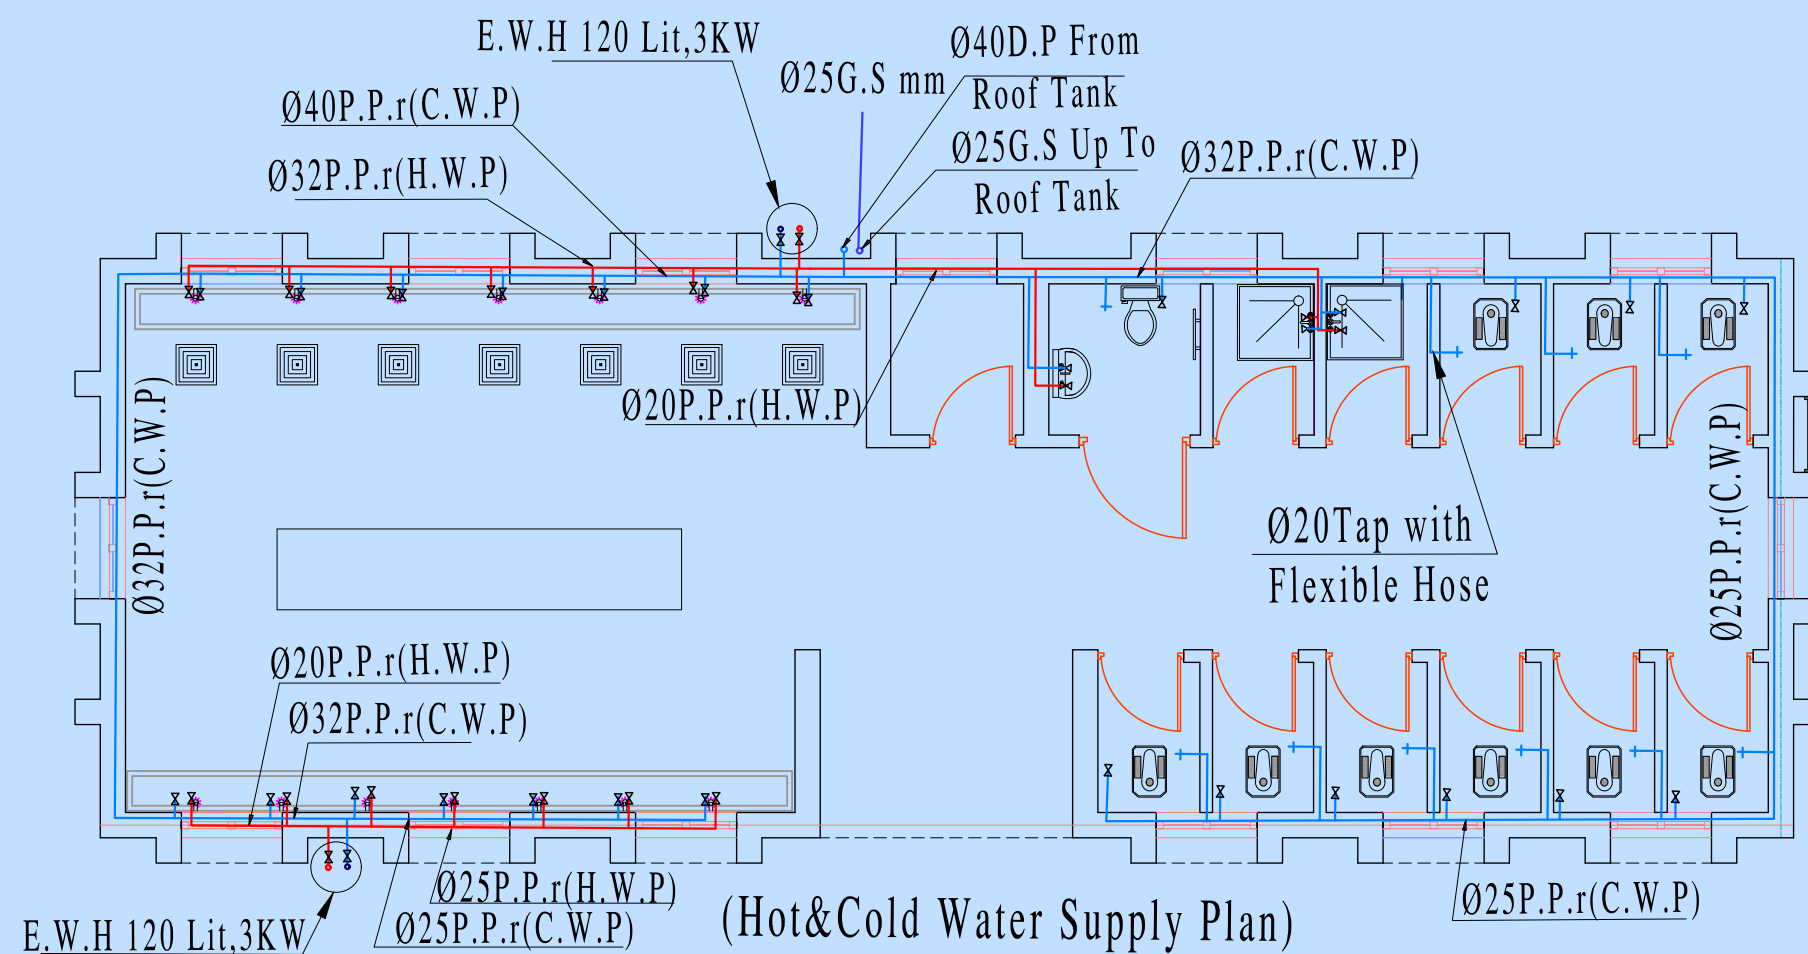

no	date	initials	revision
job title			
(A)			
drawing title			
Hot&Cold Water Supply Plan			
designed	DR : Majid Albana		project manager
checked	scale	1-100	date
drawn	job no.		sheet no.
approved			



M

Eng MAJ D A bana

المصمم الاستشاري


د. ماجد البنا

+964 770 272 4811

+964 782 595 3403

www.majidalbana.com


majidalbana@hotmail.com

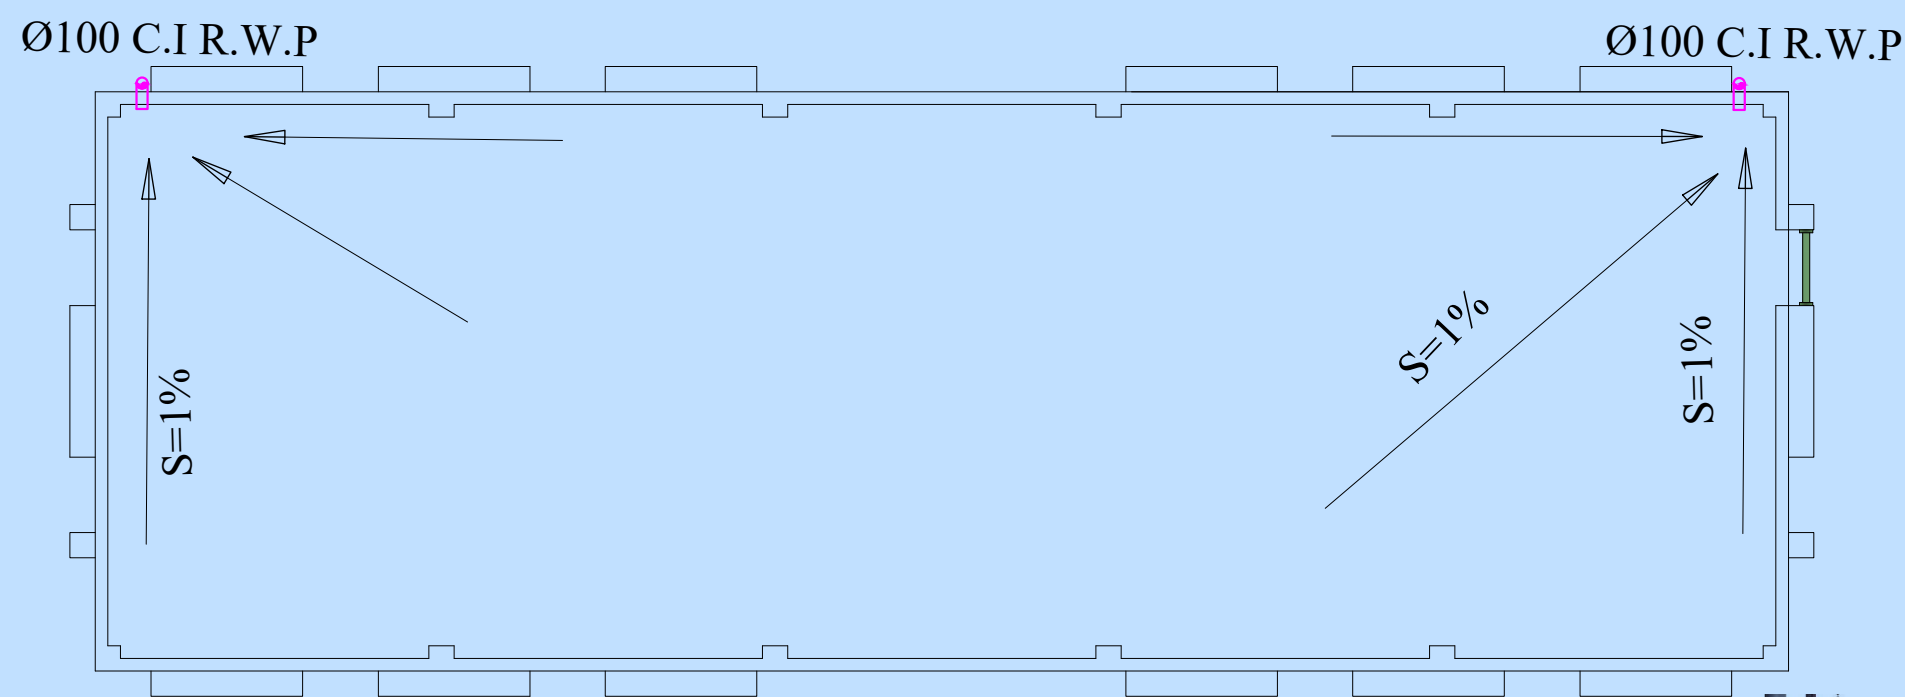

(Rain Water Pipes)


Ø40 Down pipe
+Ø15 V.P ,up

Ø25 Riser

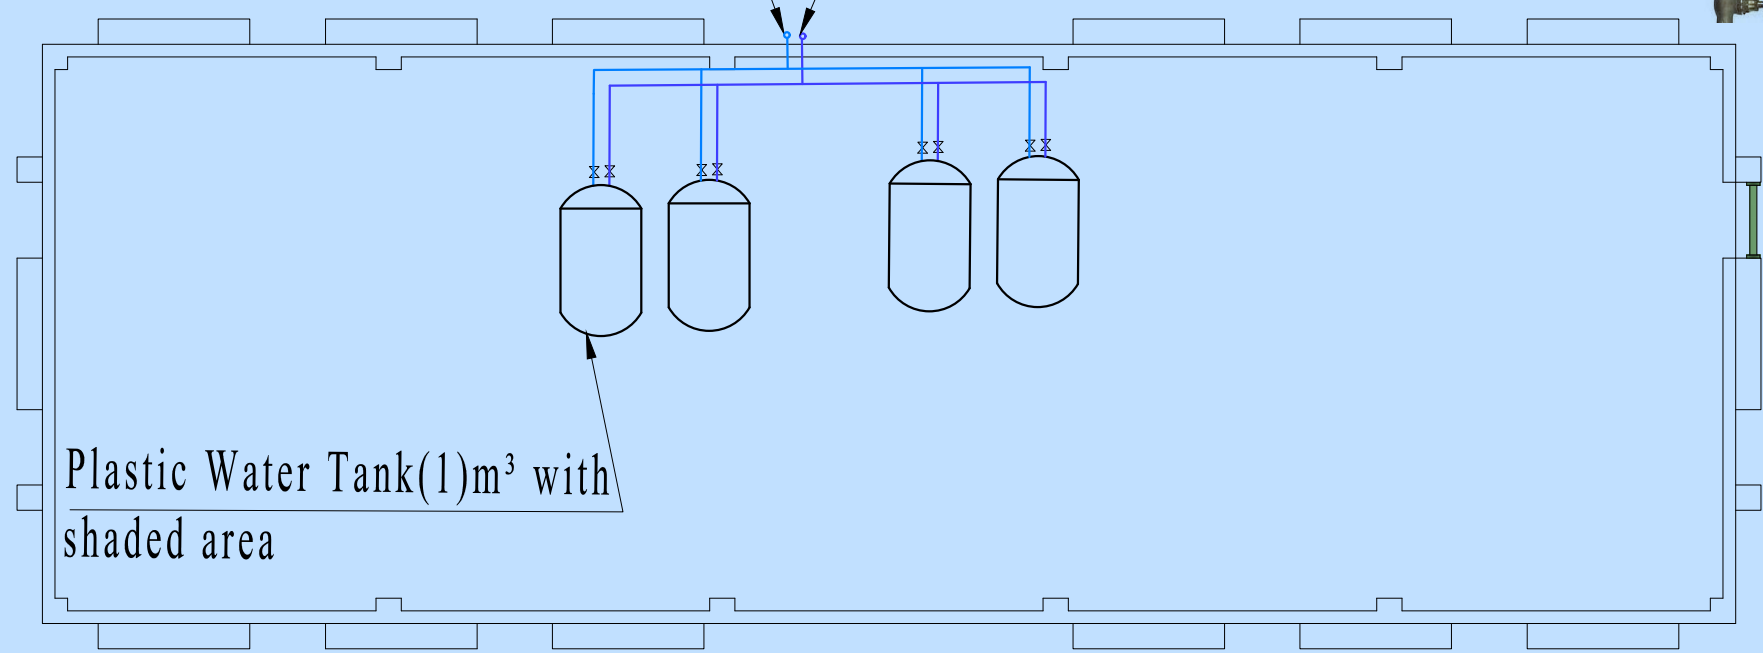

Plastic Water Tank(1)m³ with
shaded area

(Water Tanks)

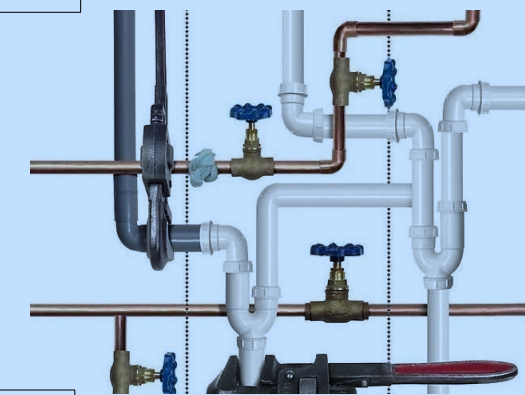

LEGEND	
SYMBOL	DESCRIPTION
	Ø110FLOOR DRAIN (F.D)
	C.O.(Ø110) CLEAN OUT
	MANHOLE FOR SEWAGE
	RAIN WATER PIPE (R.W.P)
	MAIN WATER SUPPLY PIPE(M.W.P)
	COLD WATER SUPPLY PIPE
	HOT WATER SUPPLY PIPE

no	date	initials	revision	
job title				
(A)				
drawing title				
WATER TANK				
designed DR : Majid Albana			project manager	
checked			scale 1-100	date
drawn			job no.	sheet no.
approved				



M

Eng MAJ D A bana

المصمم الاستشاري


د. ماجد البنا

+964 770 272 4811

+964 782 595 3403



www.majidalbana.com

majidalbana@hotmail.com

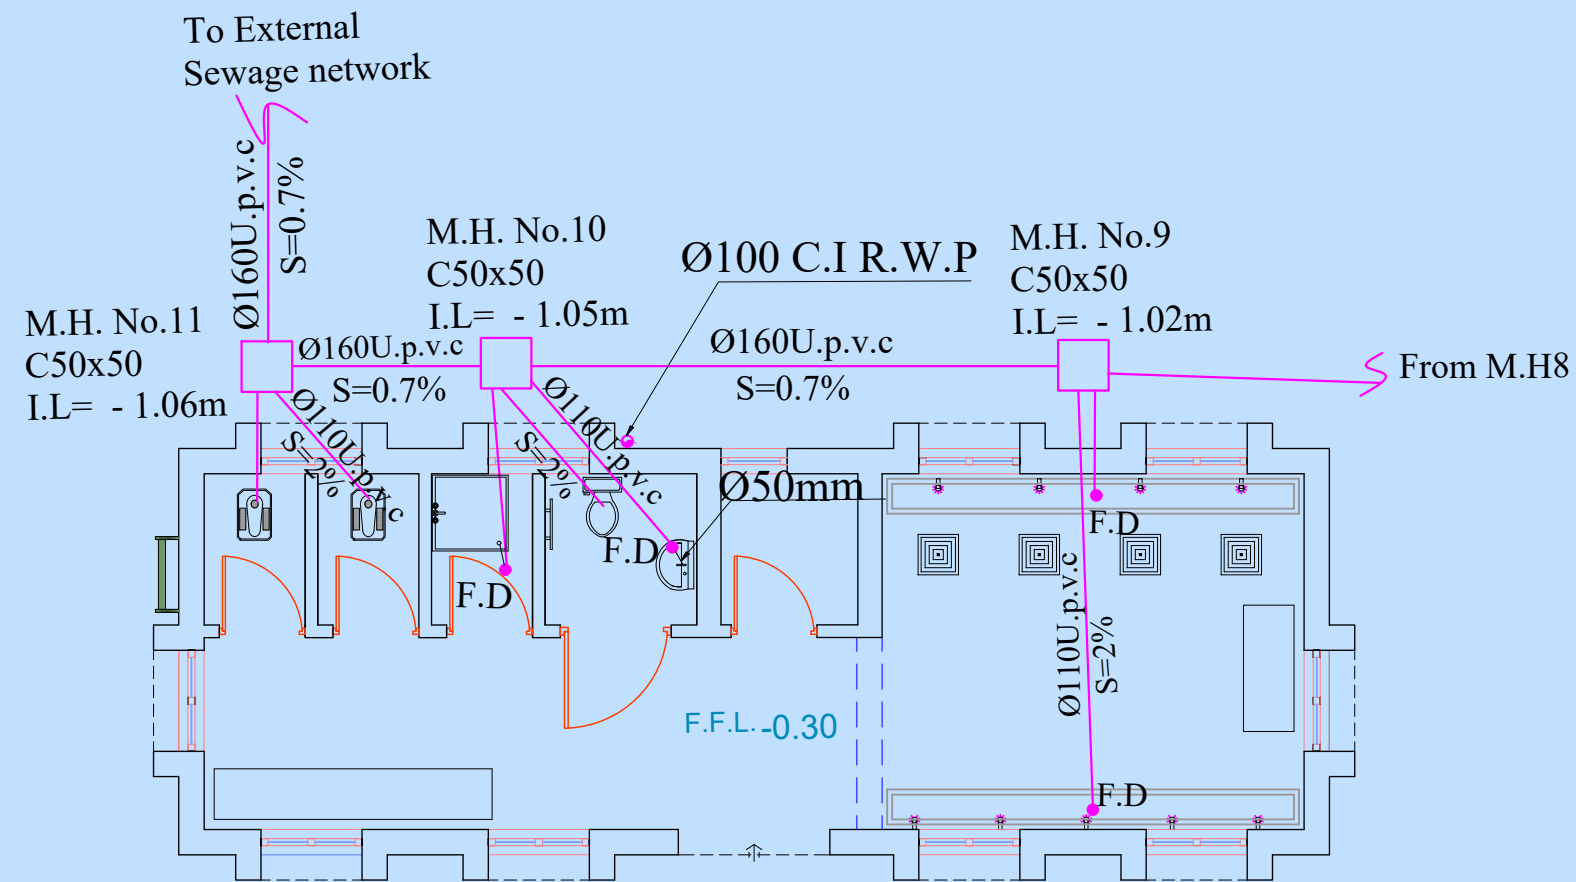


(Drainage Plan)

LEGEND	
SYMBOL	DESCRIPTION
	Ø110 FLOOR DRAIN (F.D)
	C.O.(Ø110) CLEAN OUT
	MANHOLE FOR SEWAGE
	RAIN WATER PIPE (R.W.P)
	MAIN WATER SUPPLY PIPE(M.W.P)
	COLD WATER SUPPLY PIPE
	HOT WATER SUPPLY PIPE

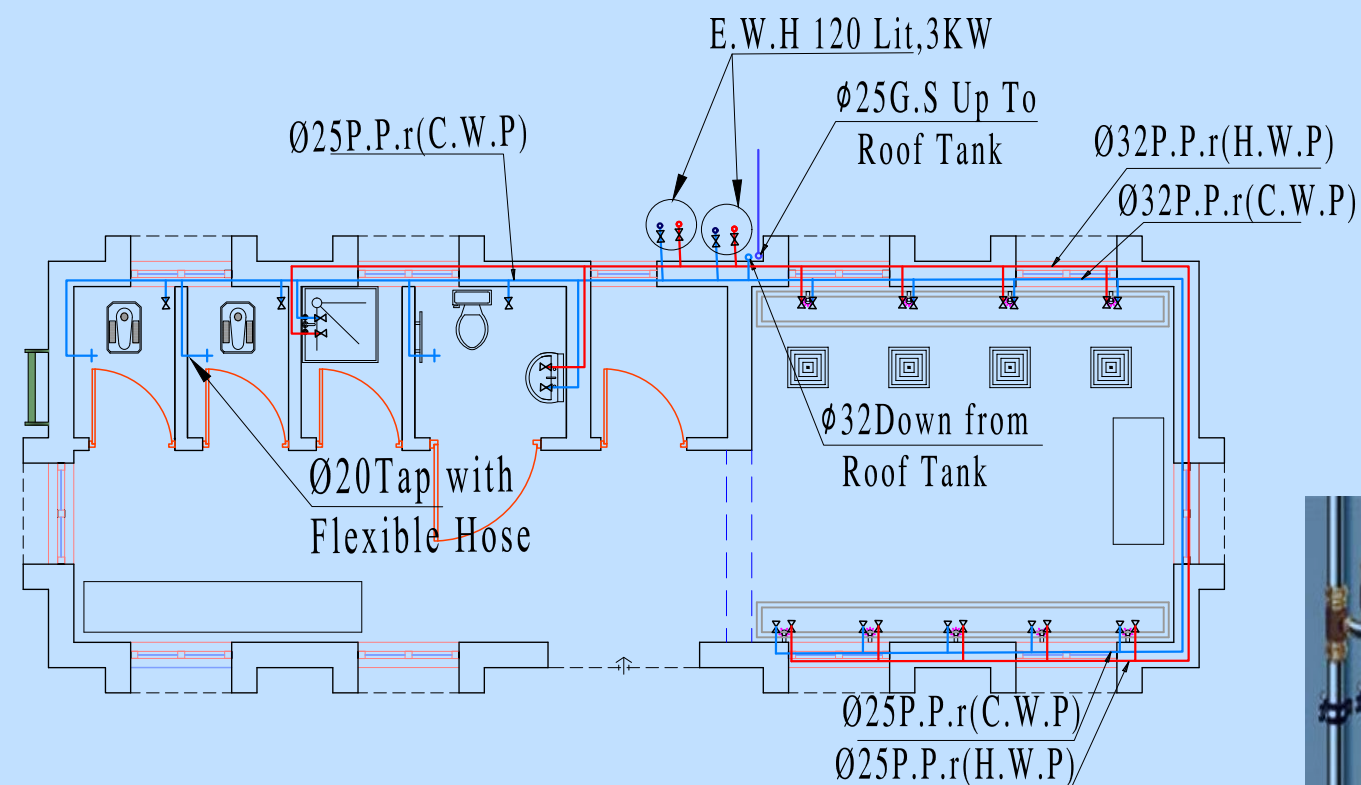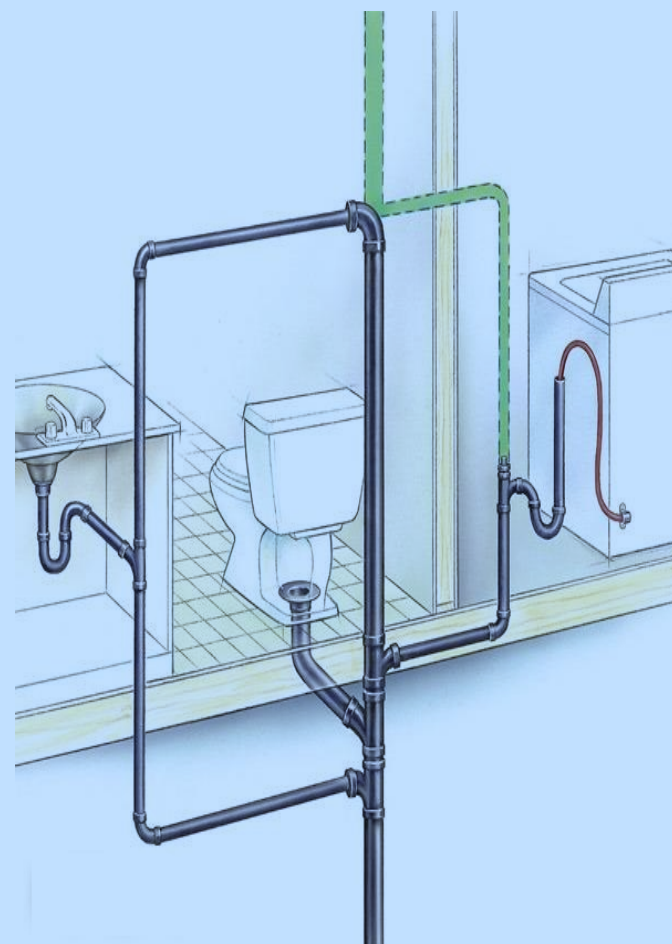

(Hot&Cold Water Supply Plan)

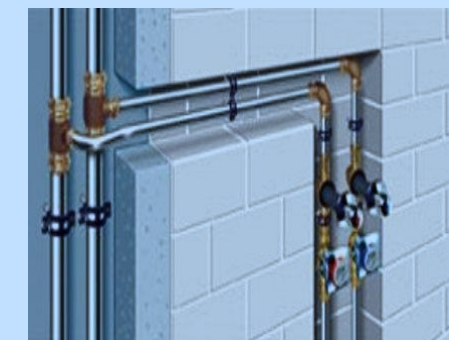

no	date	initials	revision
job title			
(A)			
drawing title			
(Hot&Cold Water Supply Plan)			
designed	DR : Majid Albana		project manager
checked	scale	1-100	date
drawn	job no.	sheet no.	
approved			



M

Eng MAJ D A bana

المصمم الاستشاري


د. ماجد البنا

+964 770 272 4811

+964 782 595 3403



www.majidalbana.com

majidalbana@hotmail.com

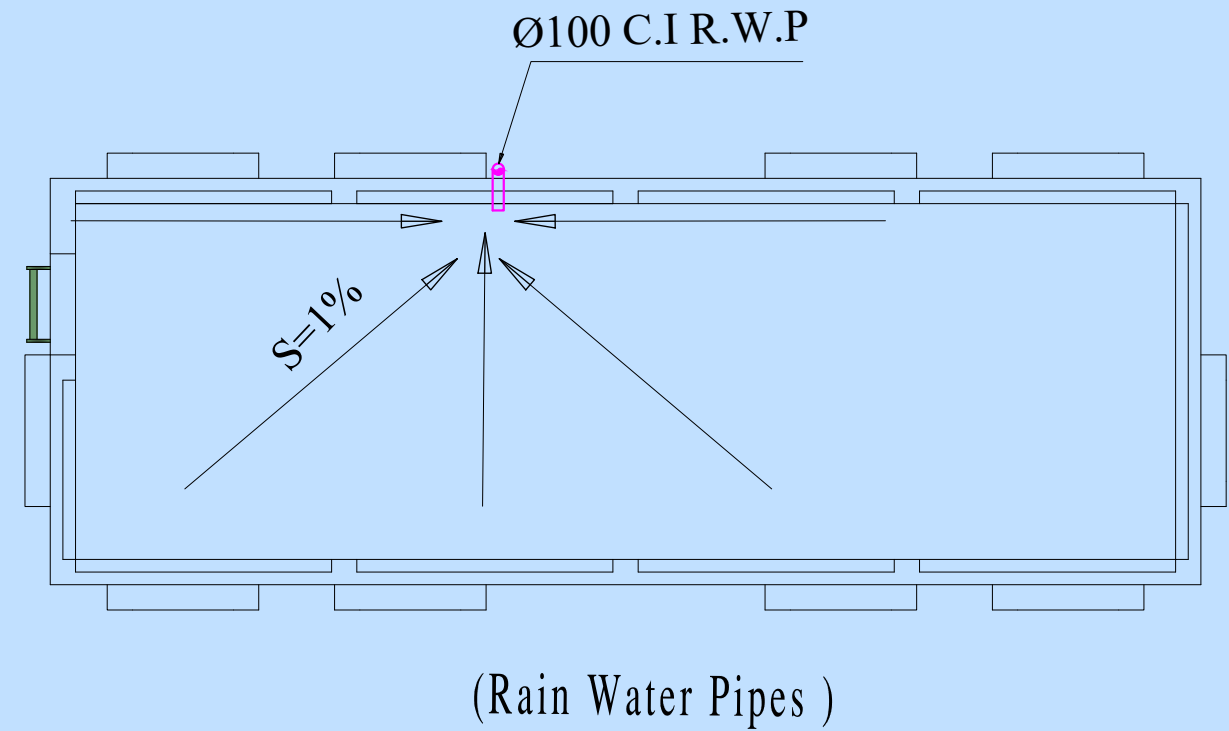

LEGEND

SYMBOLE	DESCRIPTION
Ø110	FLOOR DRAIN (F.D)
C.O.(Ø110)	CLEAN OUT
MANHOLE	FOR SEWAGE
R.W.P	RAIN WATER PIPE (R.W.P)
M.W.P	MAIN WATER SUPPLY PIPE(M.W.P)
C.W.P	COLD WATER SUPPLY PIPE
H.W.P	HOT WATER SUPPLY PIPE

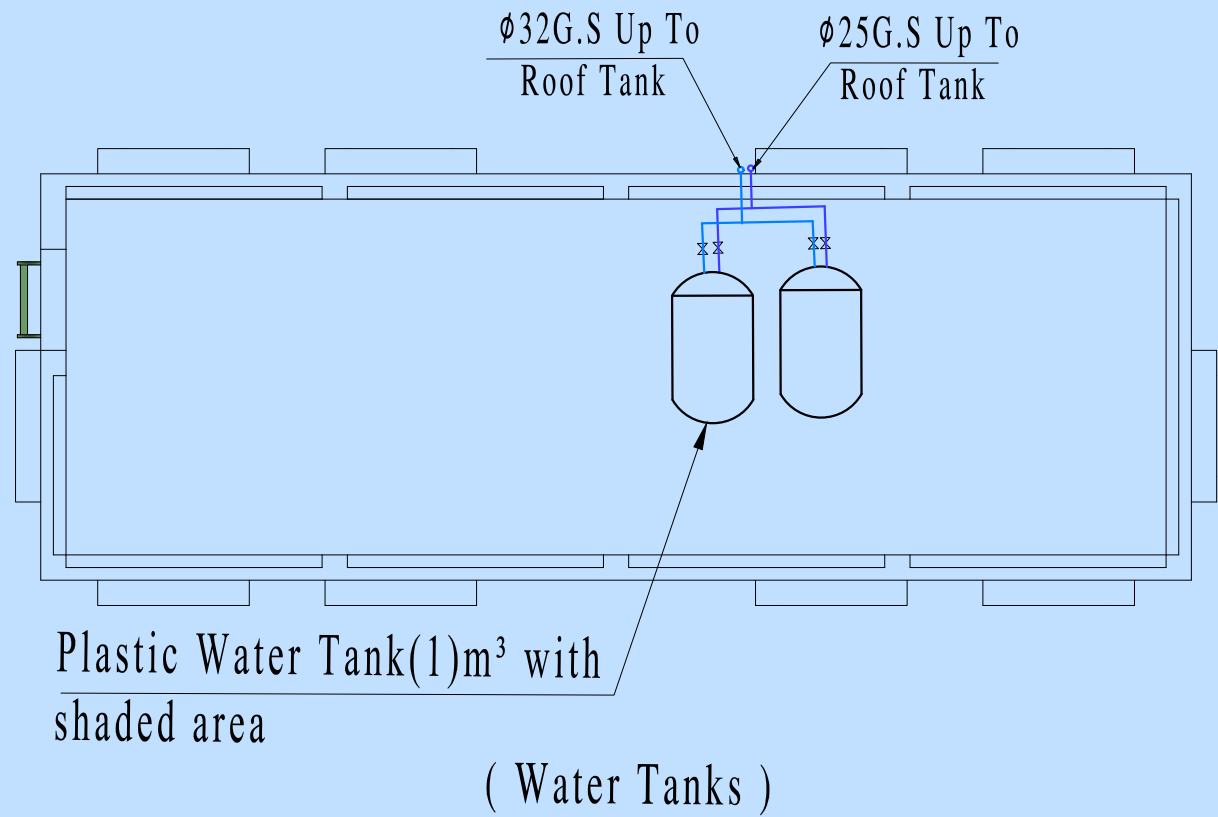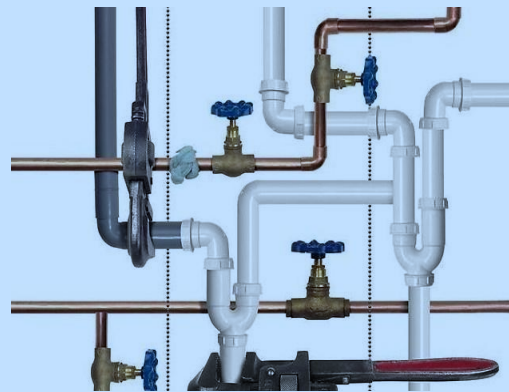

no	date	initials	revision
job title			
(A)			
drawing title			
WATER TANK			
designed DR : Majid Albana		project manager	
checked	scale 1-100	date	
drawn	job no.	sheet no.	
approved			



M

Eng MAJ D A bana

المصمم الاستشاري



د. ماجد البنا

+964 770 272 4811



+964 782 595 3403

www.majidalbana.com

majidalbana@hotmail.com

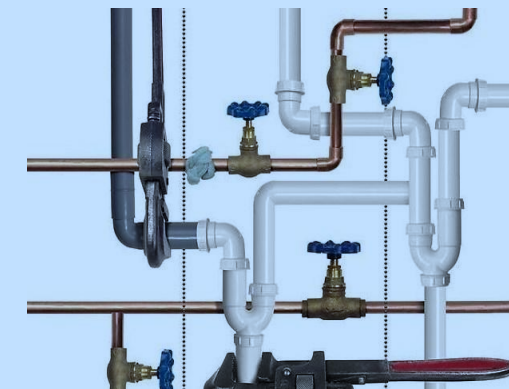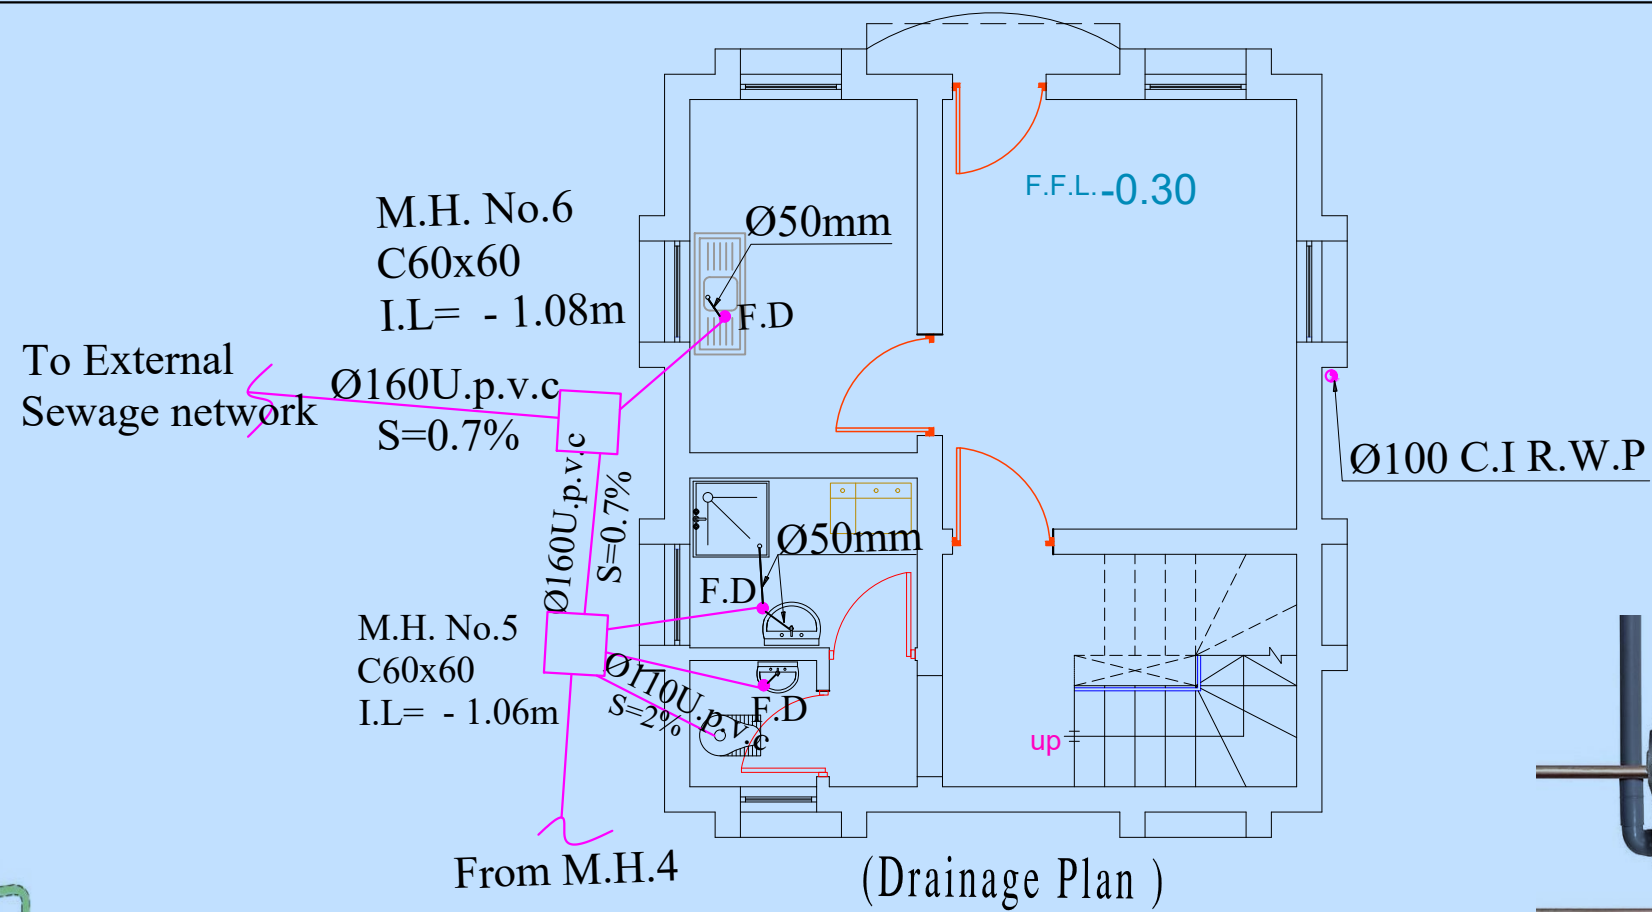

LEGEND	
SYMBOL	DESCRIPTION
	Ø110FLOOR DRAIN (F.D)
	C.O.(Ø110) CLEAN OUT
	MANHOLE FOR SEWAGE
	RAIN WATER PIPE (R.W.P)
	MAIN WATER SUPPLY PIPE(M.W.P)
	COLD WATER SUPPLY PIPE
	HOT WATER SUPPLY PIPE

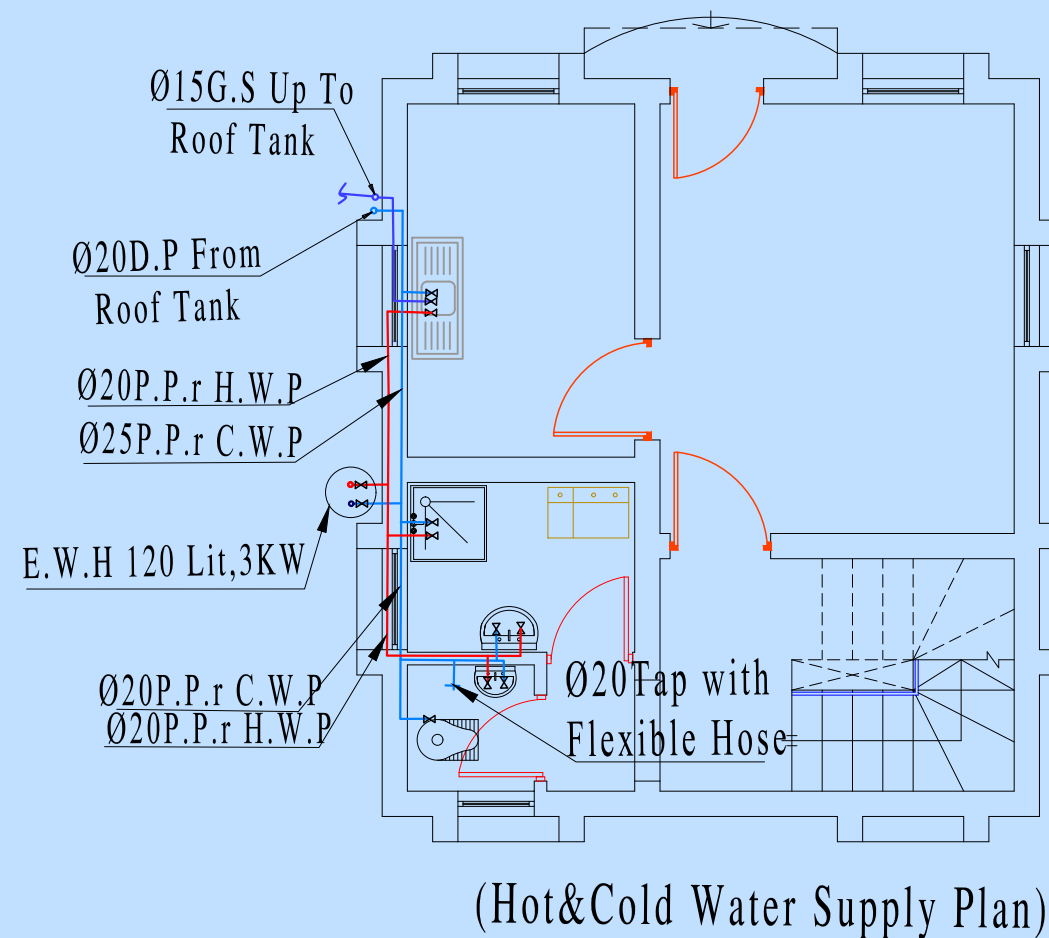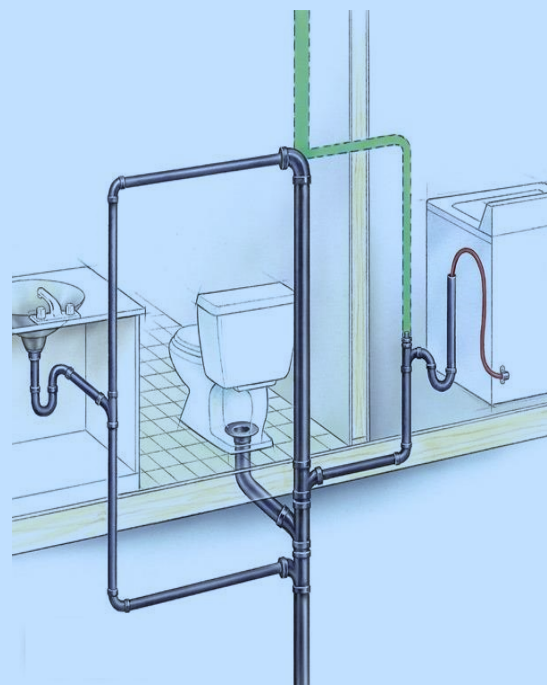

no	date	initials	revision
job title			
(A)			
drawing title			
Drainage Plan Ground Floor			
designed	project manager		
DR : Majid Albana	scale	1-100	date
checked	drawn	job no.	sheet no.
approved			



M

Eng MAJ D A bana

المصمم الاستشاري


د. ماجد البنا

+964 770 272 4811


+964 782 595 3403

www.majidalbana.com

majidalbana@hotmail.com

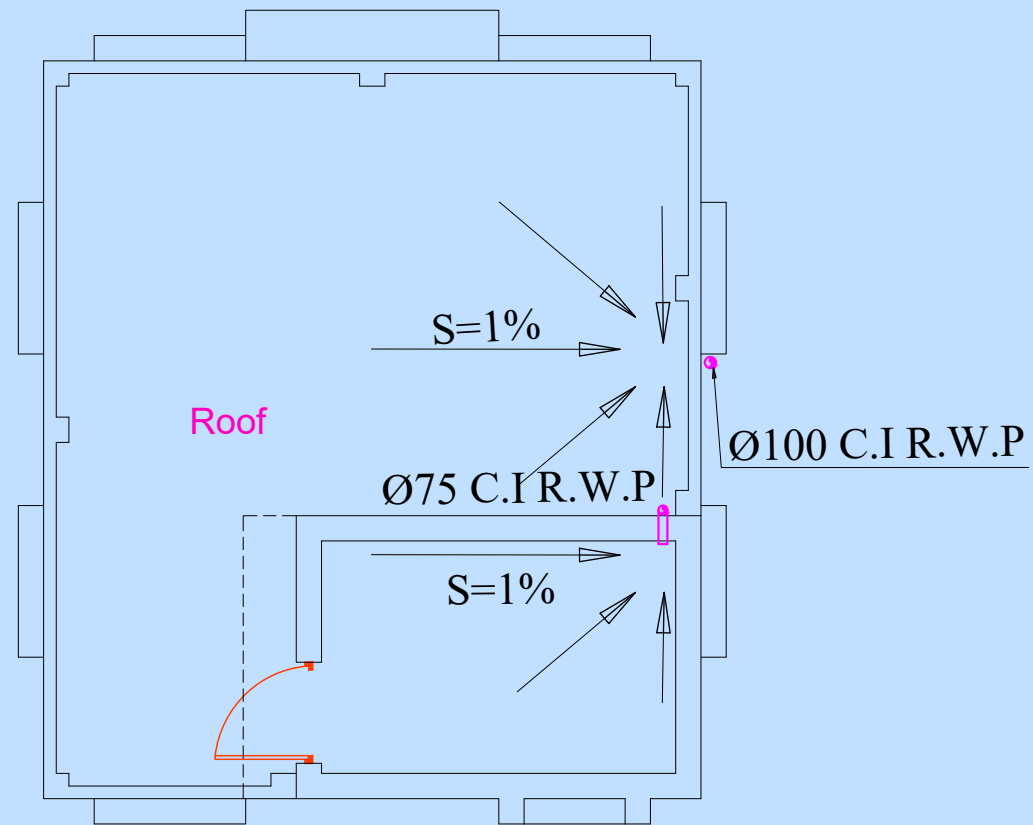

(Rain Water Pipes)

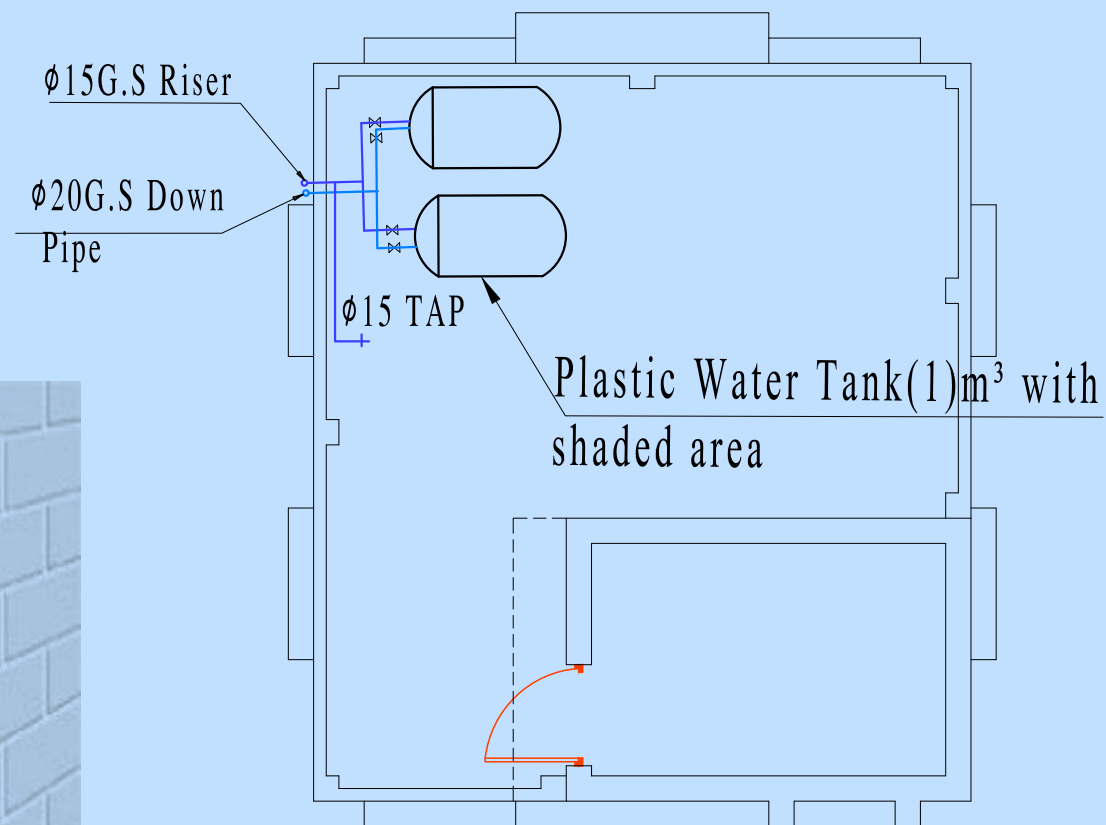


(Water Tanks)



LEGEND	
SYMBOLE	DESCRIPTION
	Ø110FLOOR DRAIN (F.D)
	C.O.(Ø110) CLEAN OUT
	MANHOLE FOR SEWAGE
	RAIN WATER PIPE (R.W.P)
	MAIN WATER SUPPLY PIPE(M.W.P)
	COLD WATER SUPPLY PIPE
	HOT WATER SUPPLY PIPE

no	date	initials	revision
job title			
(A)			
drawing title			
Drainage Plan WATER TANK			
designed DR : Majid Albana		project manager	
checked	scale 1-100	date	
drawn	job no.	sheet no.	
approved			

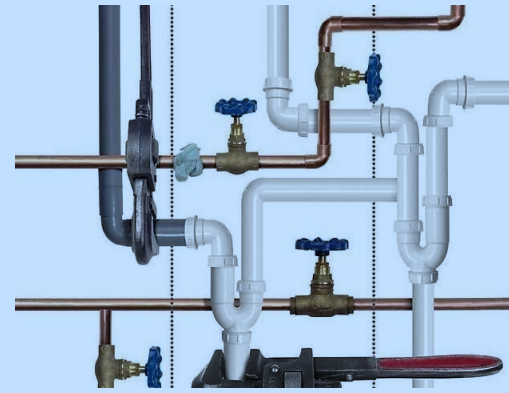

M

Eng MAJ D A bana

المصمم الاستشاري


د. ماجد البنا

+964 770 272 4811

+964 782 595 3403

www.majidalbana.com

majidalbana@hotmail.com

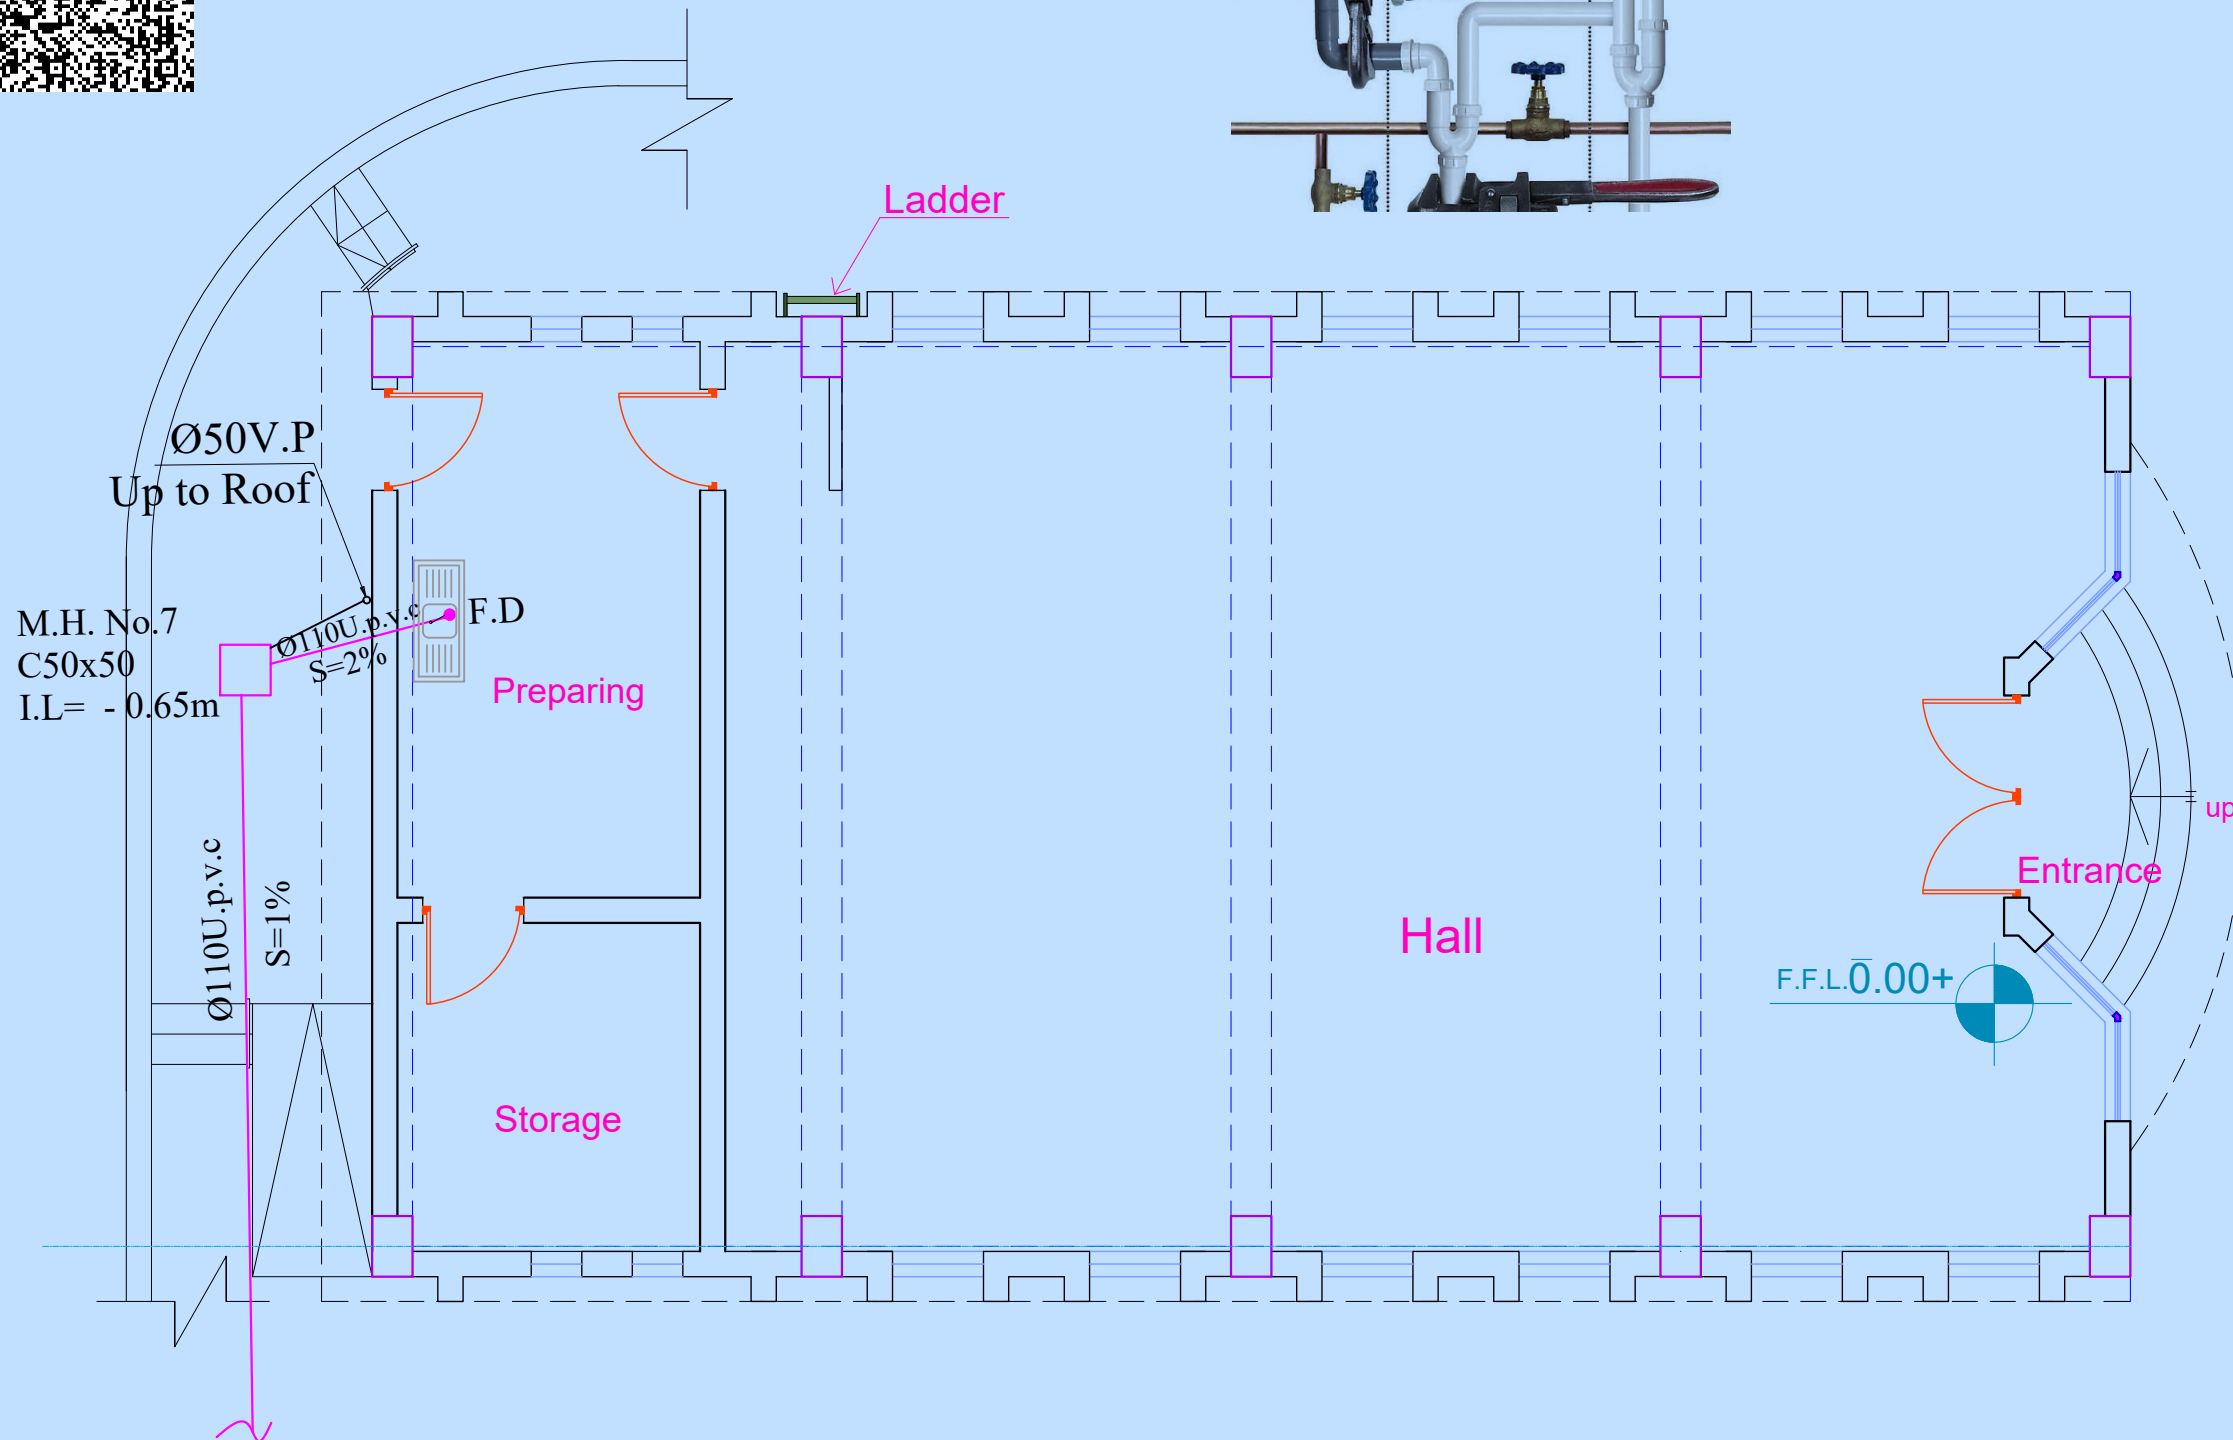

LEGEND	
SYMBOL	DESCRIPTION
	Ø110FLOOR DRAIN (F.D)
	C.O.(Ø110) CLEAN OUT
	MANHOLE FOR SEWAGE
	RAIN WATER PIPE (R.W.P)
	MAIN WATER SUPPLY PIPE(M.W.P)
	COLD WATER SUPPLY PIPE
	HOT WATER SUPPLY PIPE

Ground Floor Plan


no	date	initials	revision	
job title				
(A)				
drawing title				
Drainage Plan Ground Floor				
designed DR : Majid Albana		project manager		
checked	scale 1-100		date	
drawn	job no.		sheet no.	
approved				





Eng MAJ D A bana
المصمم الاستشاري
د. ماجد البنا

+964 770 272 4811
+964 782 595 3403
www.majidalbana.com
majidalbana@hotmail.com

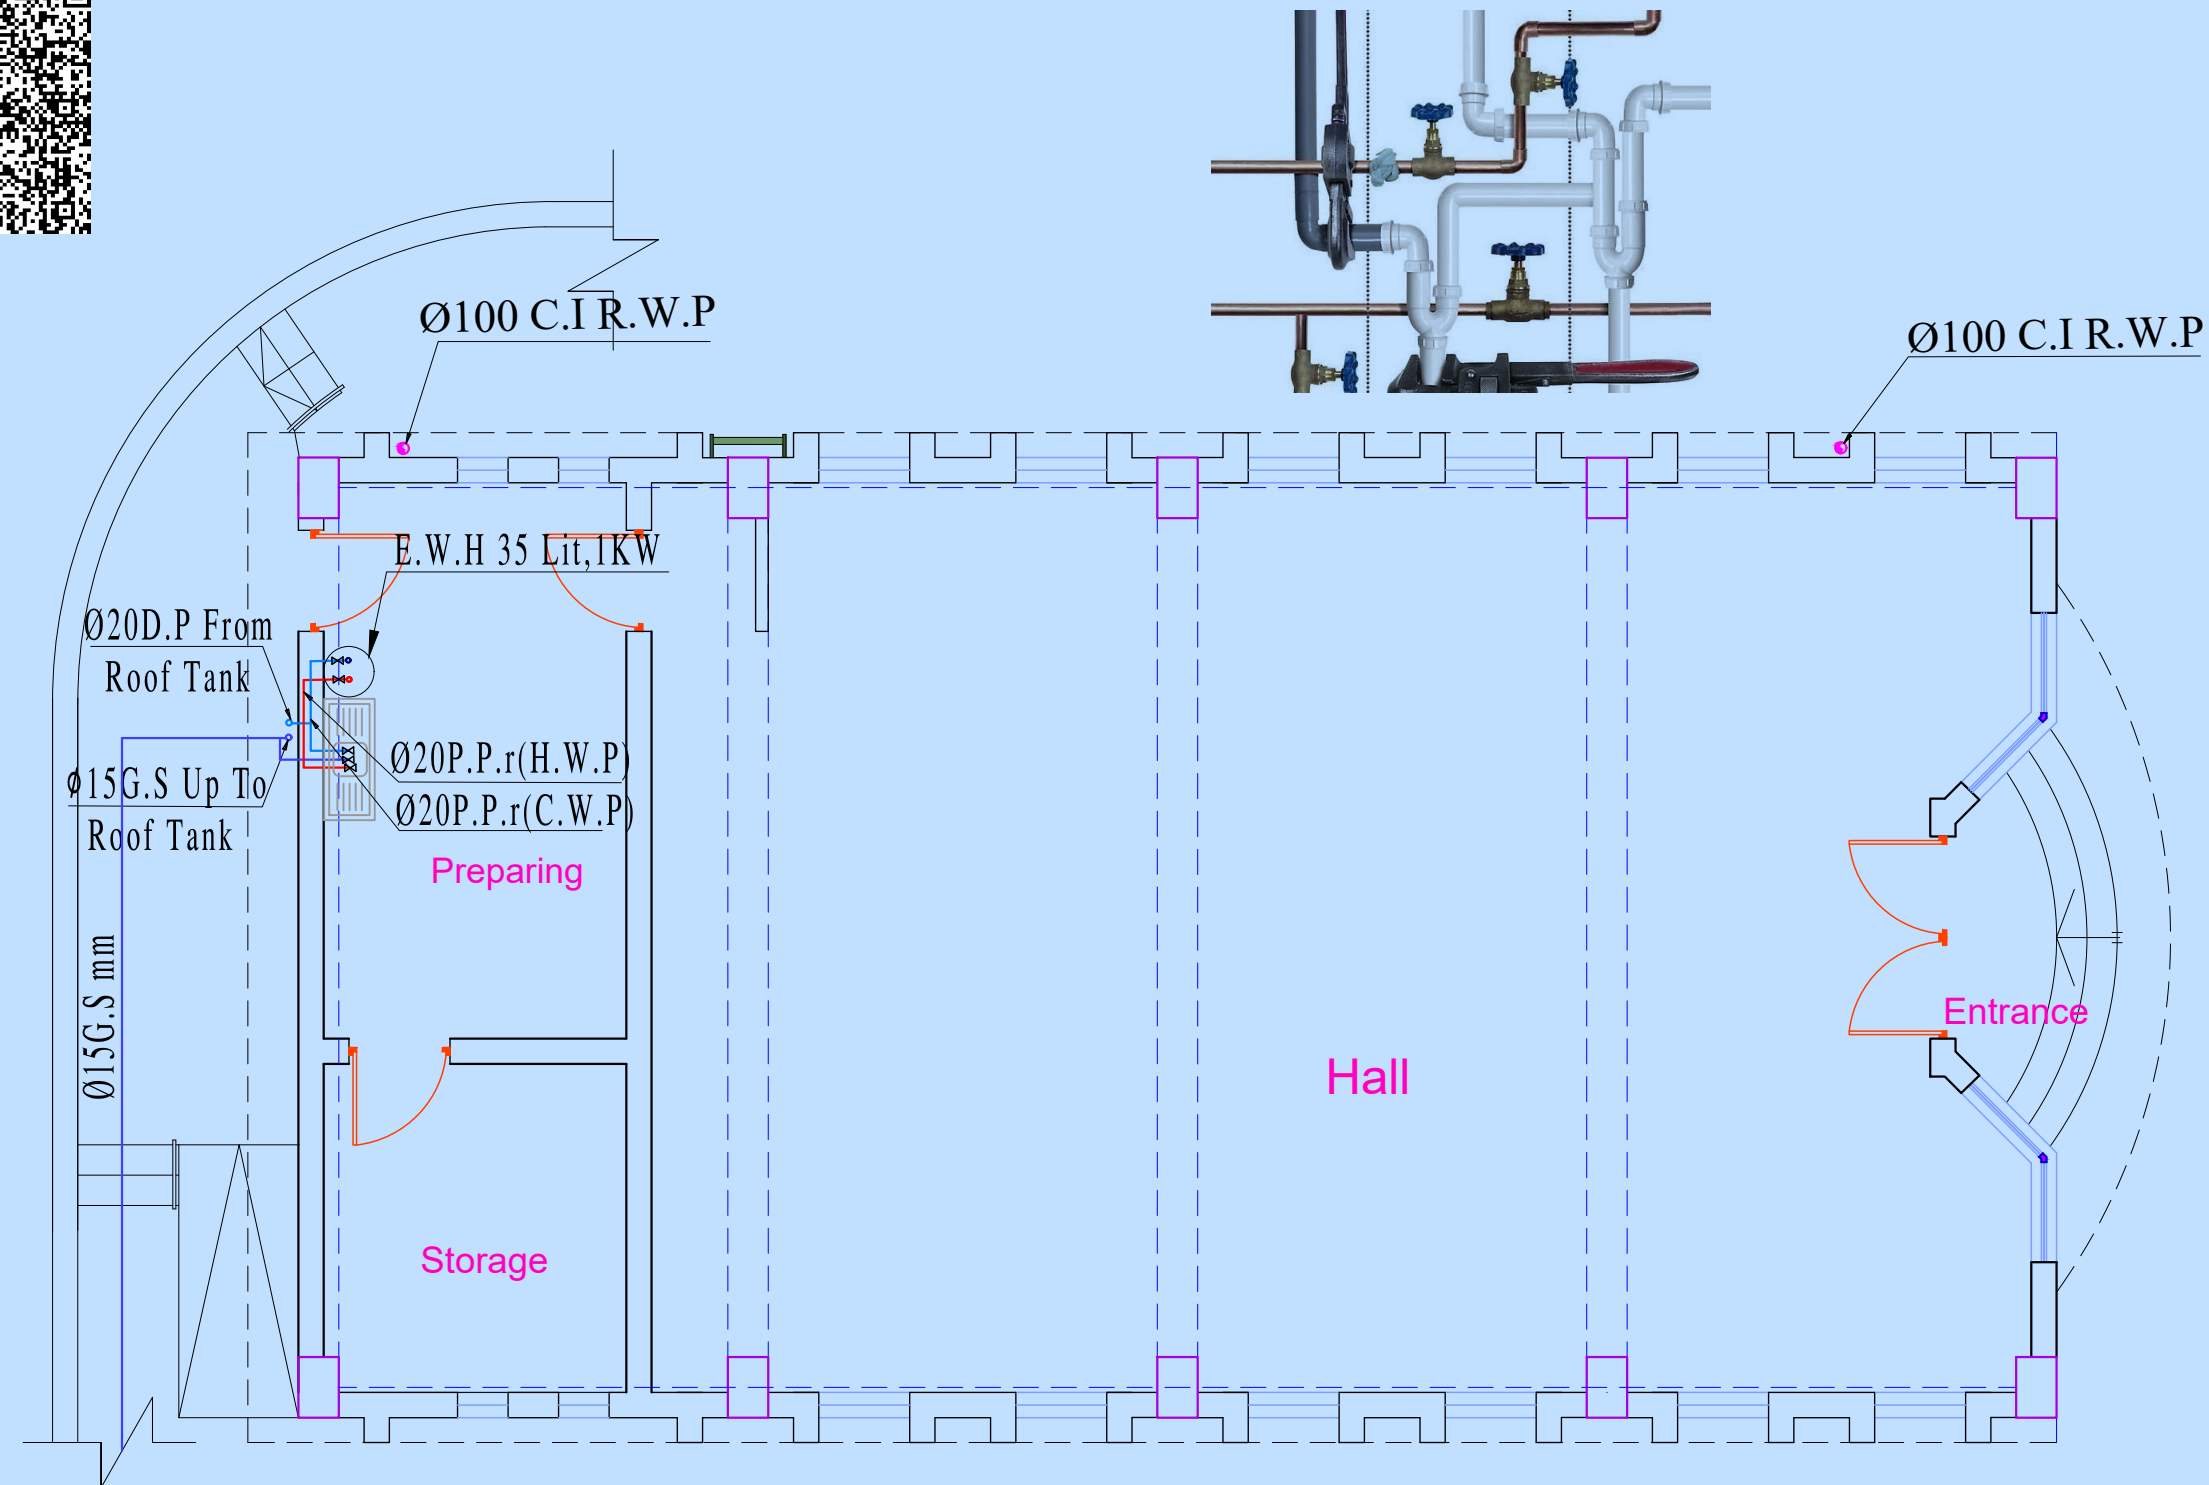

LEGEND	
SYMBOL	DESCRIPTION
	Ø110FLOOR DRAIN (F.D.)
	C.O.(Ø110) CLEAN OUT
	MANHOLE FOR SEWAGE
	RAIN WATER PIPE (R.W.P.)
	MAIN WATER SUPPLY PIPE(M.W.P)
	COLD WATER SUPPLY PIPE
	HOT WATER SUPPLY PIPE

Ground Floor Plan

no.	date	initials	revision
job title			
(A)			
drawing title			
Drainage Plan Ground Floor			
designed DR : Majid Albana	project manager		
checked	scale 1-100	date	
drawn	job no.	sheet no.	
approved			



M

Eng MAJ D A bana

المصمم الاستشاري


د. ماجد البنا

+964 770 272 4811

+964 782 595 3403

www.majidalbana.com

majidalbana@hotmail.com

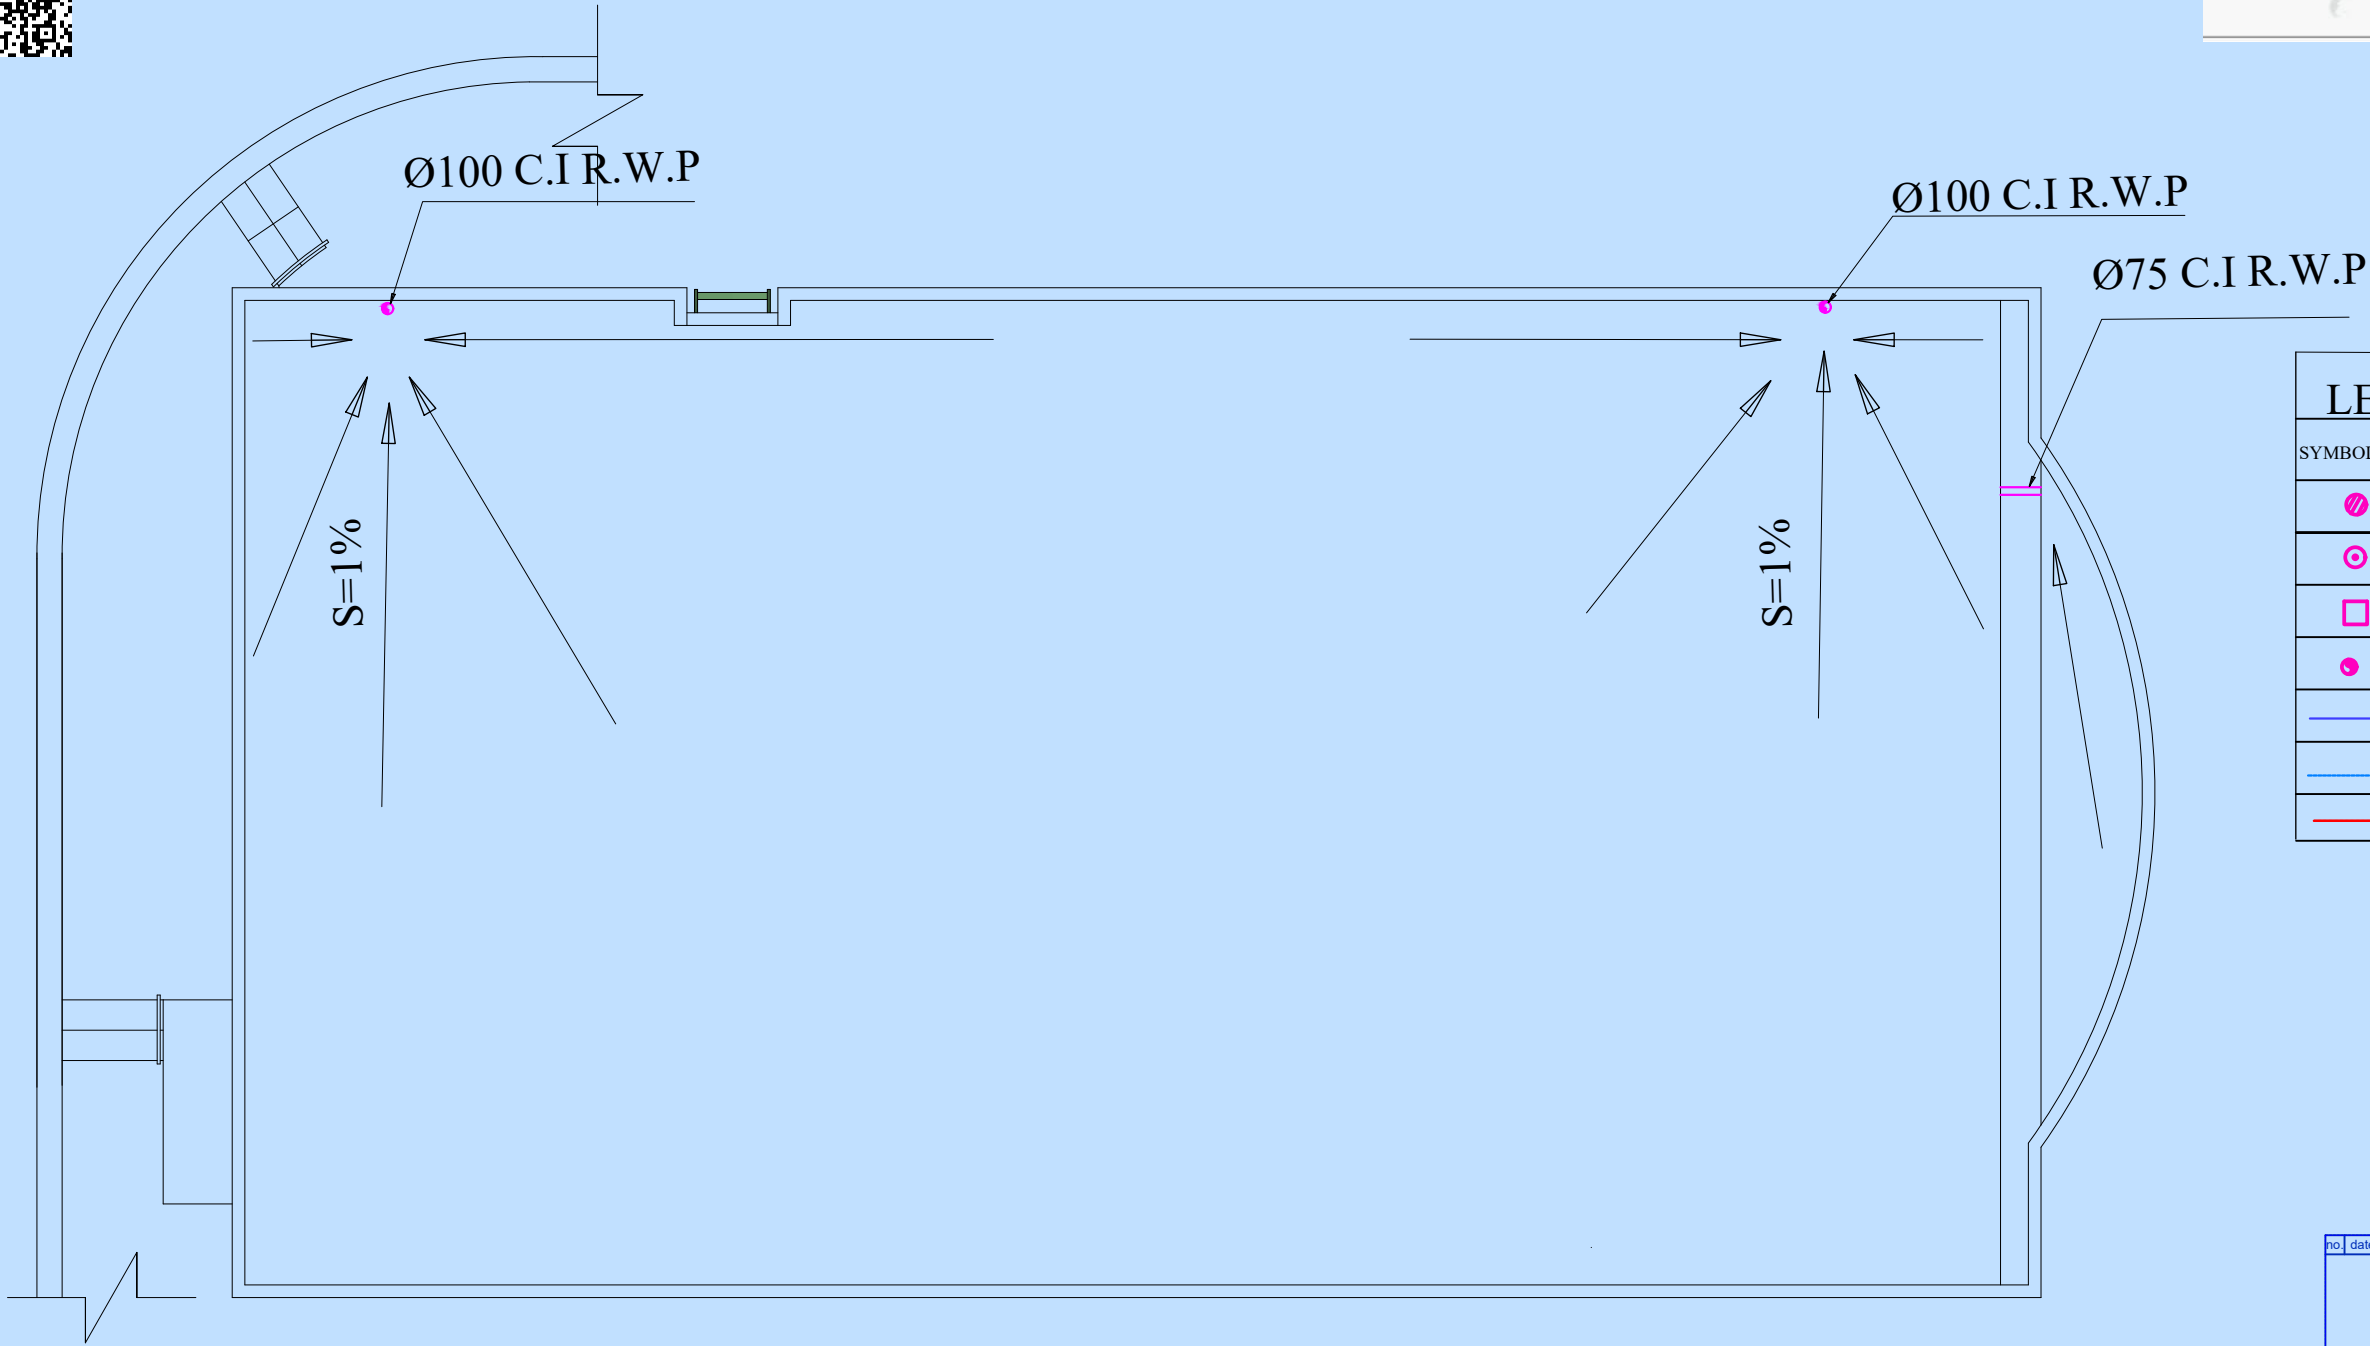

LEGEND	
SYMBOLE	DESCRIPTION
Ø100 F.D.	Ø100 FLOOR DRAIN (F.D)
Ø75 C.O.	C.O.(Ø110) CLEAN OUT
□	MANHOLE FOR SEWAGE
●	RAIN WATER PIPE (R.W.P)
—	MAIN WATER SUPPLY PIPE(M.W.P)
—	COLD WATER SUPPLY PIPE
—	HOT WATER SUPPLY PIPE

no	date	initials	revision
job title			
(A)			
drawing title			
Drainage Plan Ground Floor			
designed	DR : Majid Albana		project manager
checked	scale	1-100	date
drawn	job no.		sheet no.
approved			



M

Eng MAJ D A bana


المصمم الاستشاري
د. ماجد البنا

+964 770 272 4811

+964 782 595 3403

www.majidalbana.com

majidalbana@hotmail.com

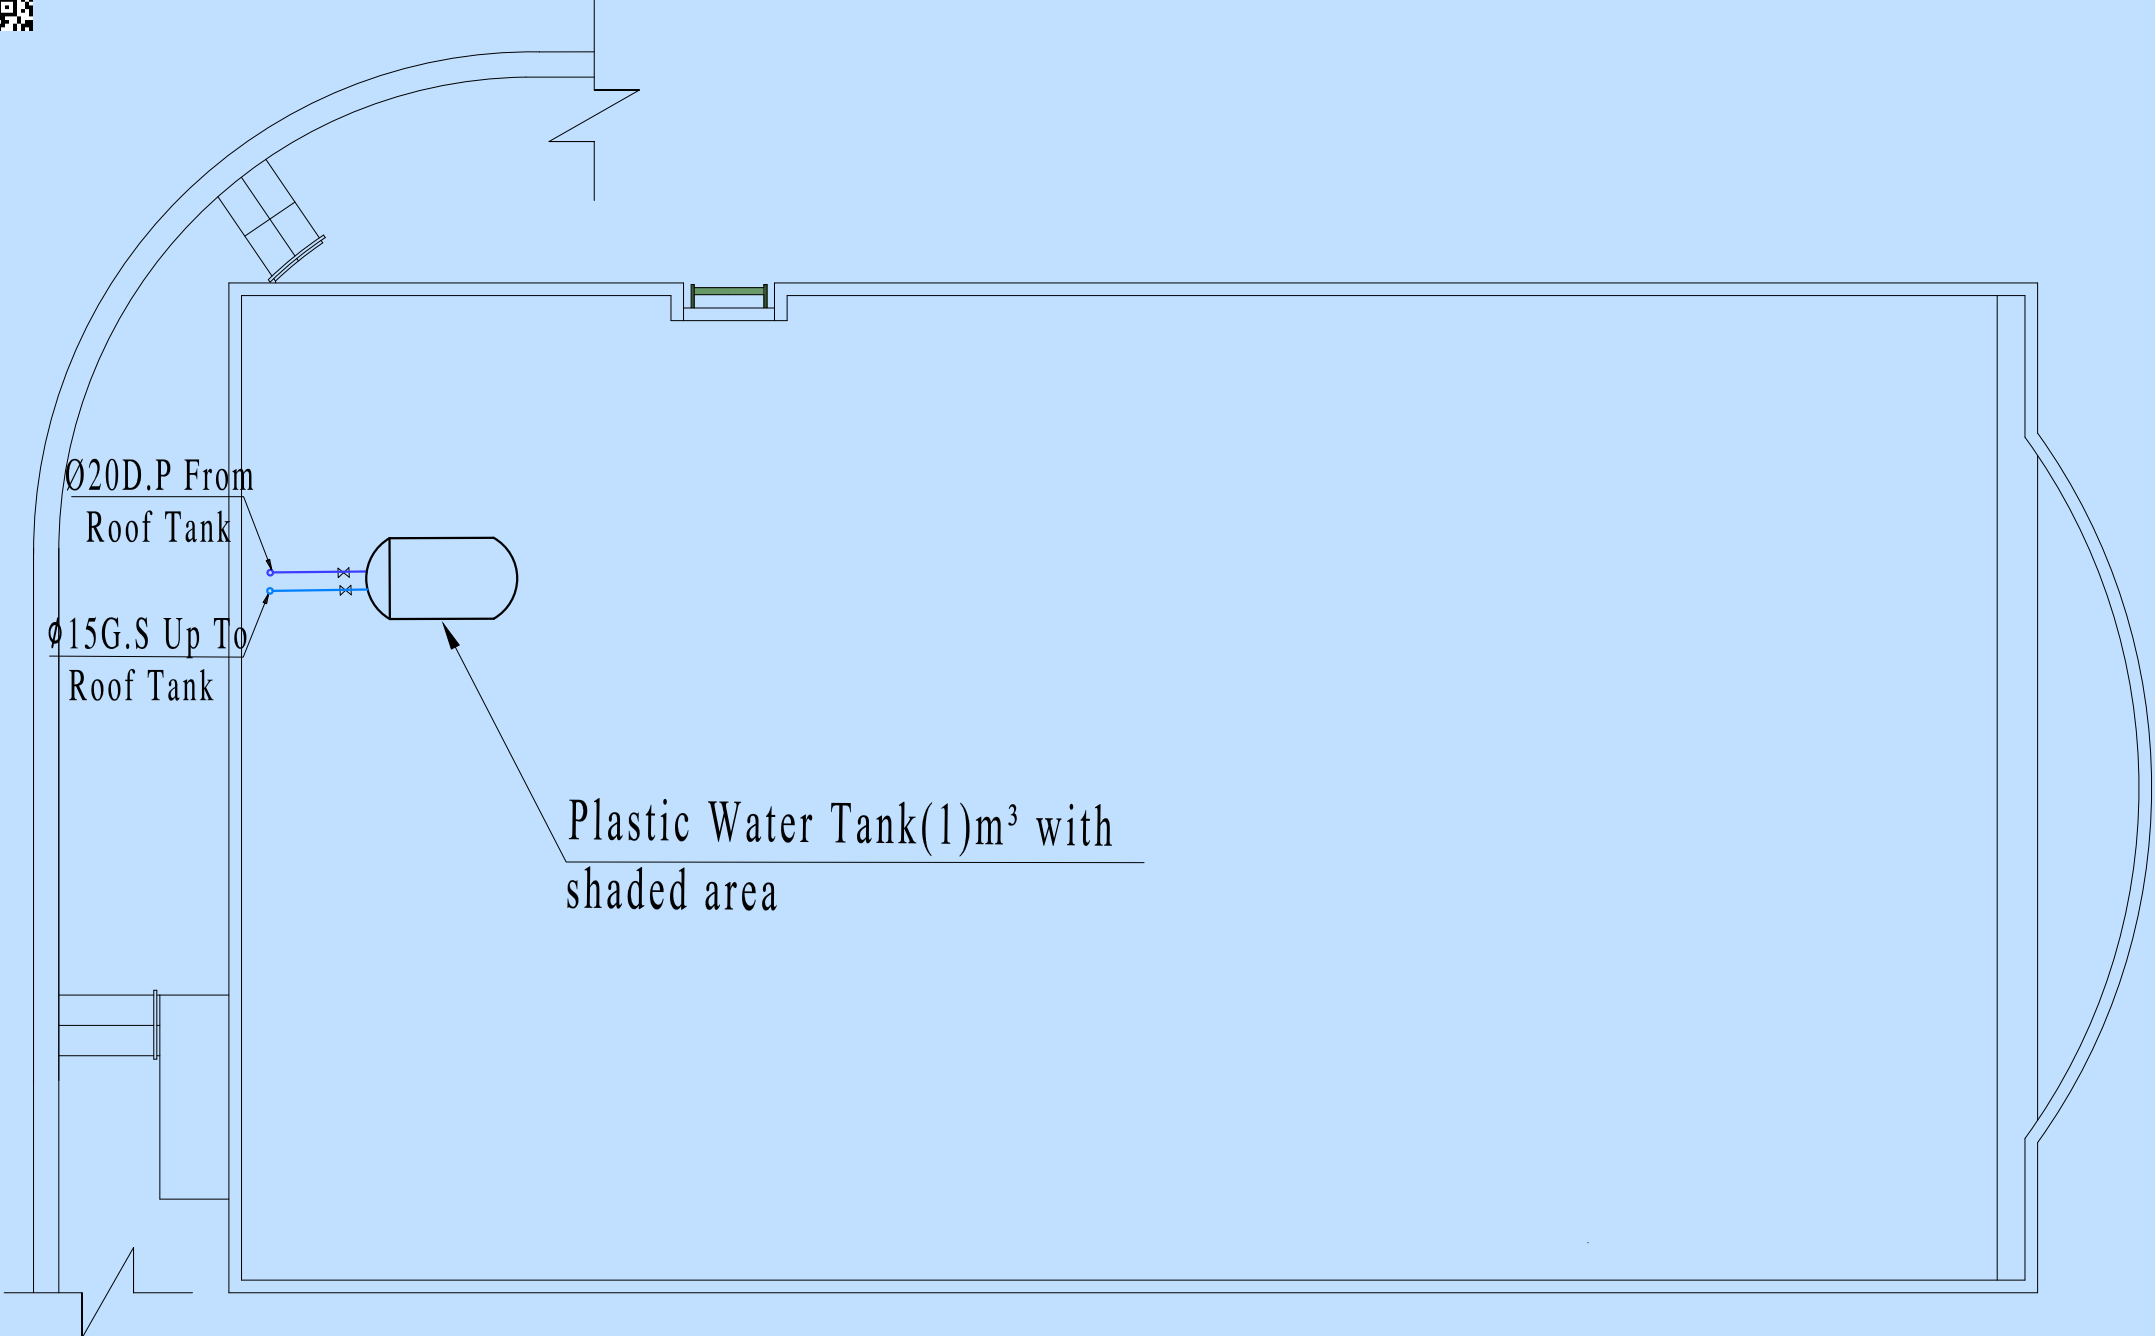

Roof Plan

LEGEND	
SYMBOL	DESCRIPTION
	Ø110FLOOR DRAIN (F.D)
	C.O.(Ø110) CLEAN OUT
	MANHOLE FOR SEWAGE
	RAIN WATER PIPE (R.W.P)
	MAIN WATER SUPPLY PIPE(M.W.P)
	COLD WATER SUPPLY PIPE
	HOT WATER SUPPLY PIPE

no	date	initials	revision	
job title				
(A)				
drawing title				
Drainage Plan Ground Floor				
designed DR : Majid Albana			project manager	
checked	scale 1-100		date	
drawn	job no.		sheet no.	
approved				



M

Eng MAJ D A bana

المصمم الاستشاري


د. ماجد البنا

+964 770 272 4811

+964 782 595 3403

www.majidalbana.com

majidalbana@hotmail.com

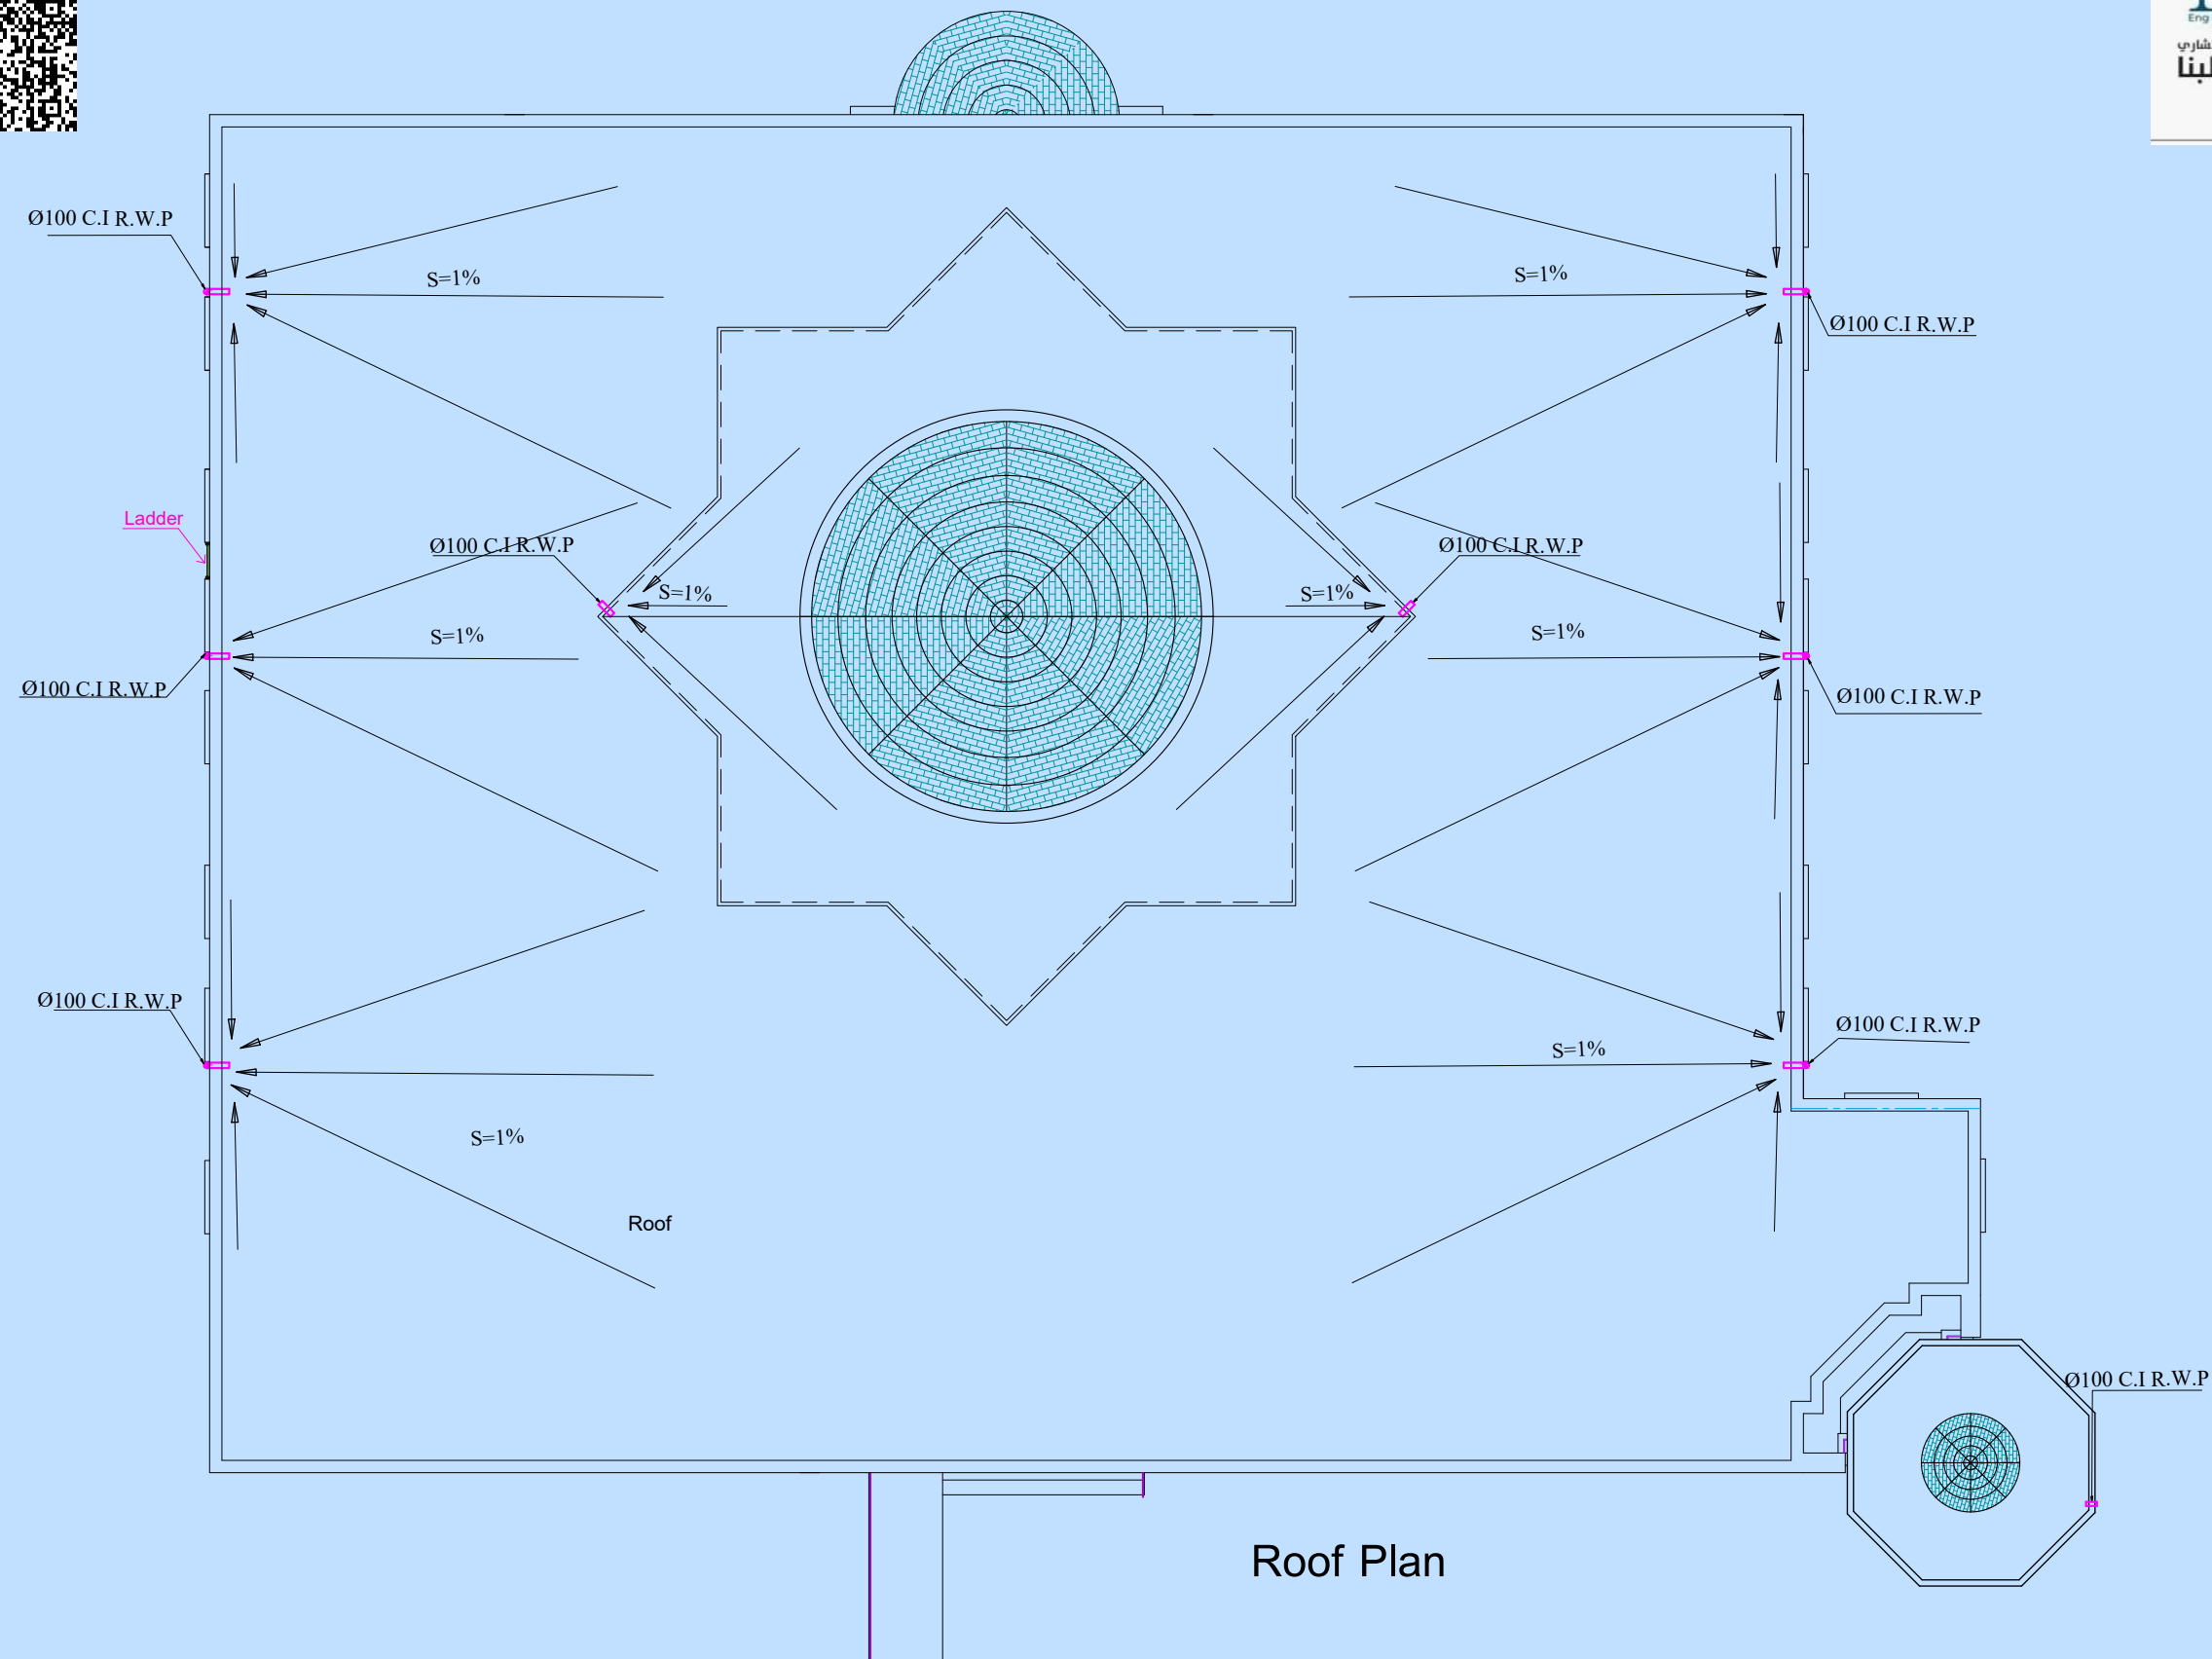

LEGEND	
SYMBOL	DESCRIPTION
	Ø110FLOOR DRAIN (F.D)
	C.O.(Ø110) CLEAN OUT
	MANHOLE FOR SEWAGE
	RAIN WATER PIPE (R.W.P)
	MAIN WATER SUPPLY PIPE(M.W.P)
	COLD WATER SUPPLY PIPE
	HOT WATER SUPPLY PIPE

no	date	initials	revision
job title			
(A)			
drawing title			
Roof Plan			
designed	DR : Majid Albana		project manager
checked		scale	date
		1-100	
drawn		job no.	sheet no.
approved			